


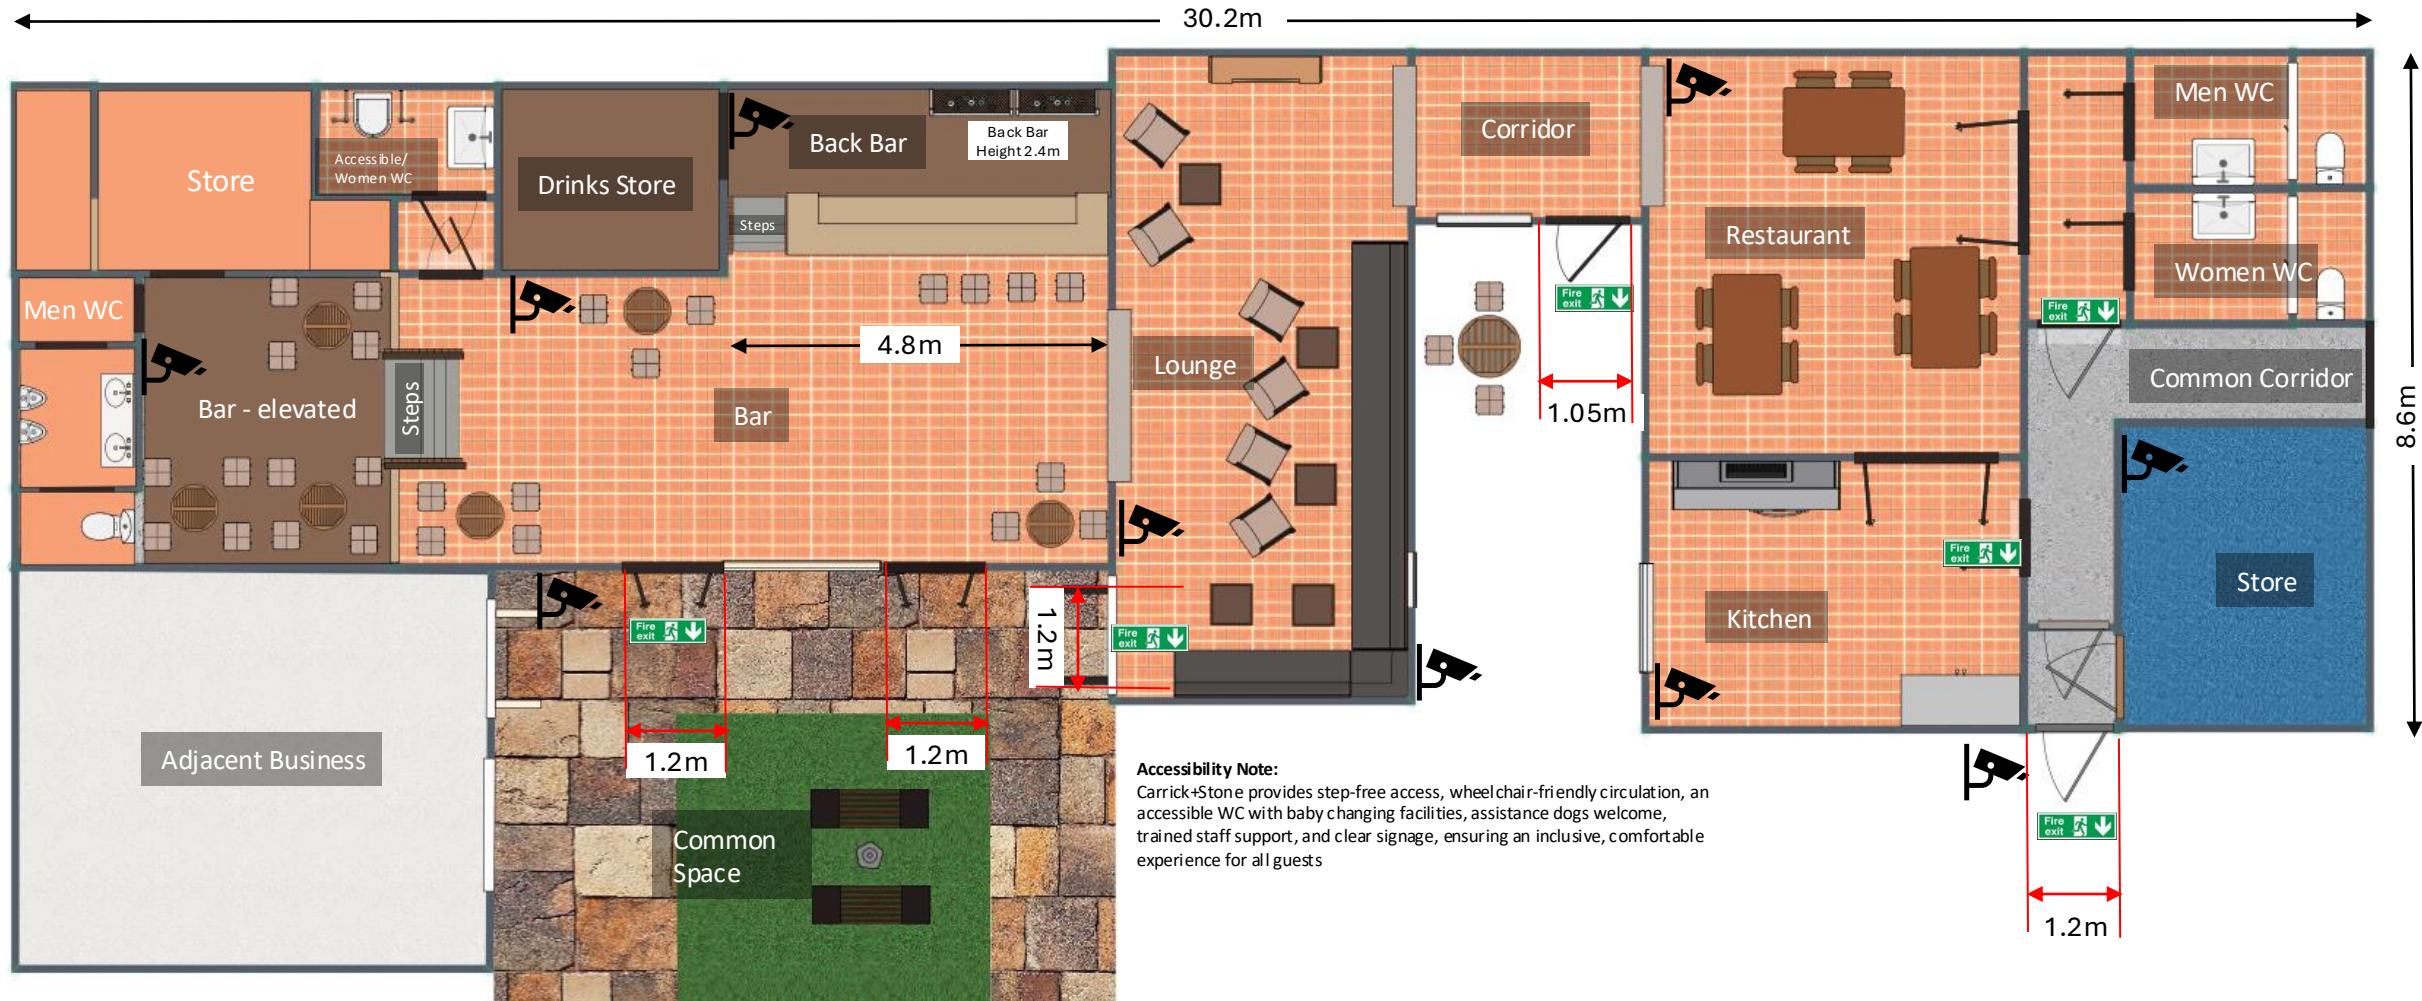

Accessibility Note:
Carrick+Stone provides step-free access, wheel chair-friendly circulation, an accessible WC with baby changing facilities, assistance dogs welcome, trained staff support, and clear signage, ensuring an inclusive, comfortable experience for all guests

Fire Detection & Warning

- Grade L2 fire alarm system
- Automatic detection in all escape routes and high-risk areas
 - Manual call points at exits
 - Audible warning throughout the premises
- Optical smoke detectors in:
- Main customer lounge seating areas
 - Circulation routes
 - Entrance lobby / reception area
 - Staircases or changes in level (if any)
 - Back-of-house corridors

- Fixed heat detectors in:
- Kitchen / food prep area
 - Bar back area where heat-generating equipment is present
 - Cellar / plant areas with compressors or electrical load
- Manual Call Points at each final exit, near main entrance and staffBoH exits
- Sounders & Warning will be clearly audible in all areas inc. WC, Cellar & Staff Area
- Visual beacons in accessible WC and areas with background music
- Fire Fighting Equipment (for use by trained staff)
- Water (RED) in lounge and circulation routes
- CO2 (Black) behind bar, near electrical panels and cellar
- Wet Chemical in Kitchen and a fire blanket
- All extinguishers wall mounted with ID signage

Area	Detection	Extinguishers
Customer Lounge	Smoke	Water
Bar	Smoke / Heat	CO ₂
Kitchen	Heat	Wet Chemical + Fire Blanket
Cellar	Heat	CO ₂
Escape Routes	Smoke	Water
Exits	Call Points	—

Emergency Lighting will illuminate all escape routes, exit doors, changes in level, fire alarm call points and firefighting equipment locations

Fire Safety Signage will include Fire Exit, Keep Clear, Fire Door and Fire Action Notices (in staff areas, behind bar and BoH)

Project Name: Carrick+Stone Restaurant and Bar	Project Address: 29-32 Queens Court, Sandgate, Ayr
Drawing Number: C+S001	Scale: not to scale
Revision: 2	Carrick+Stone