
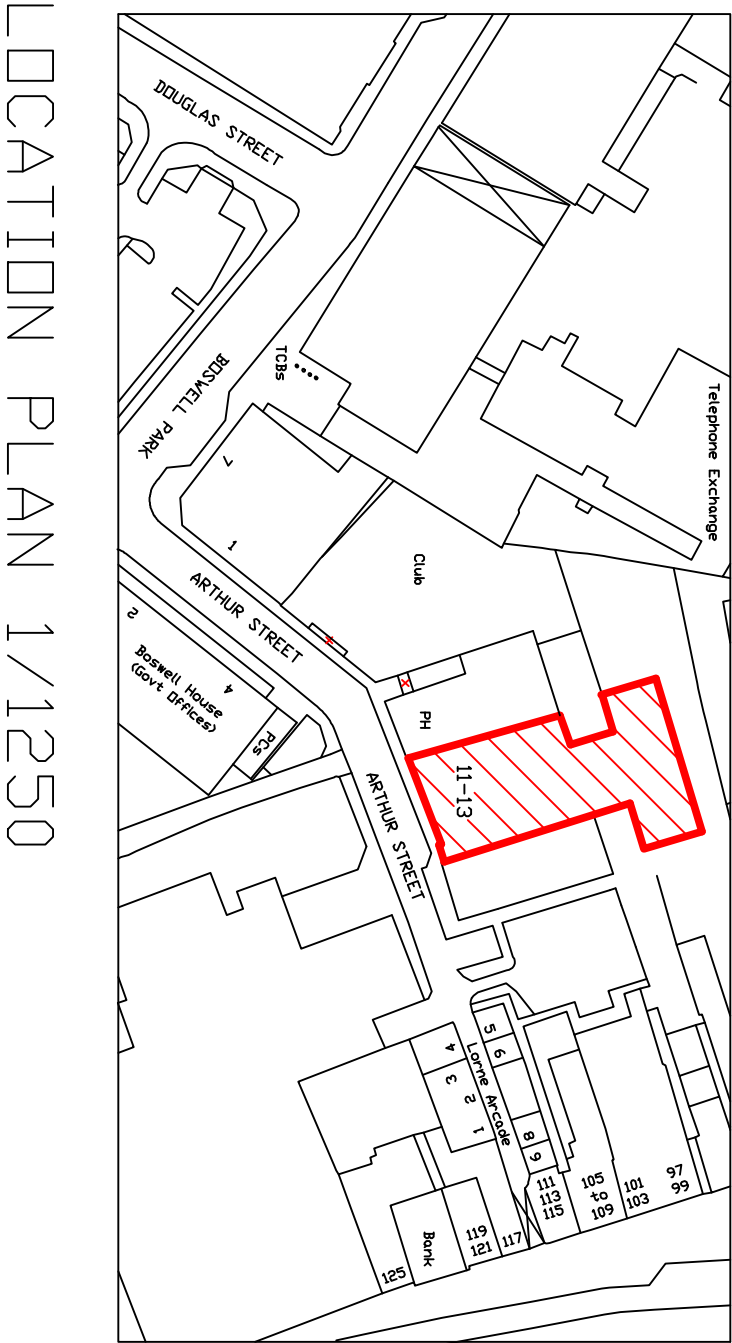


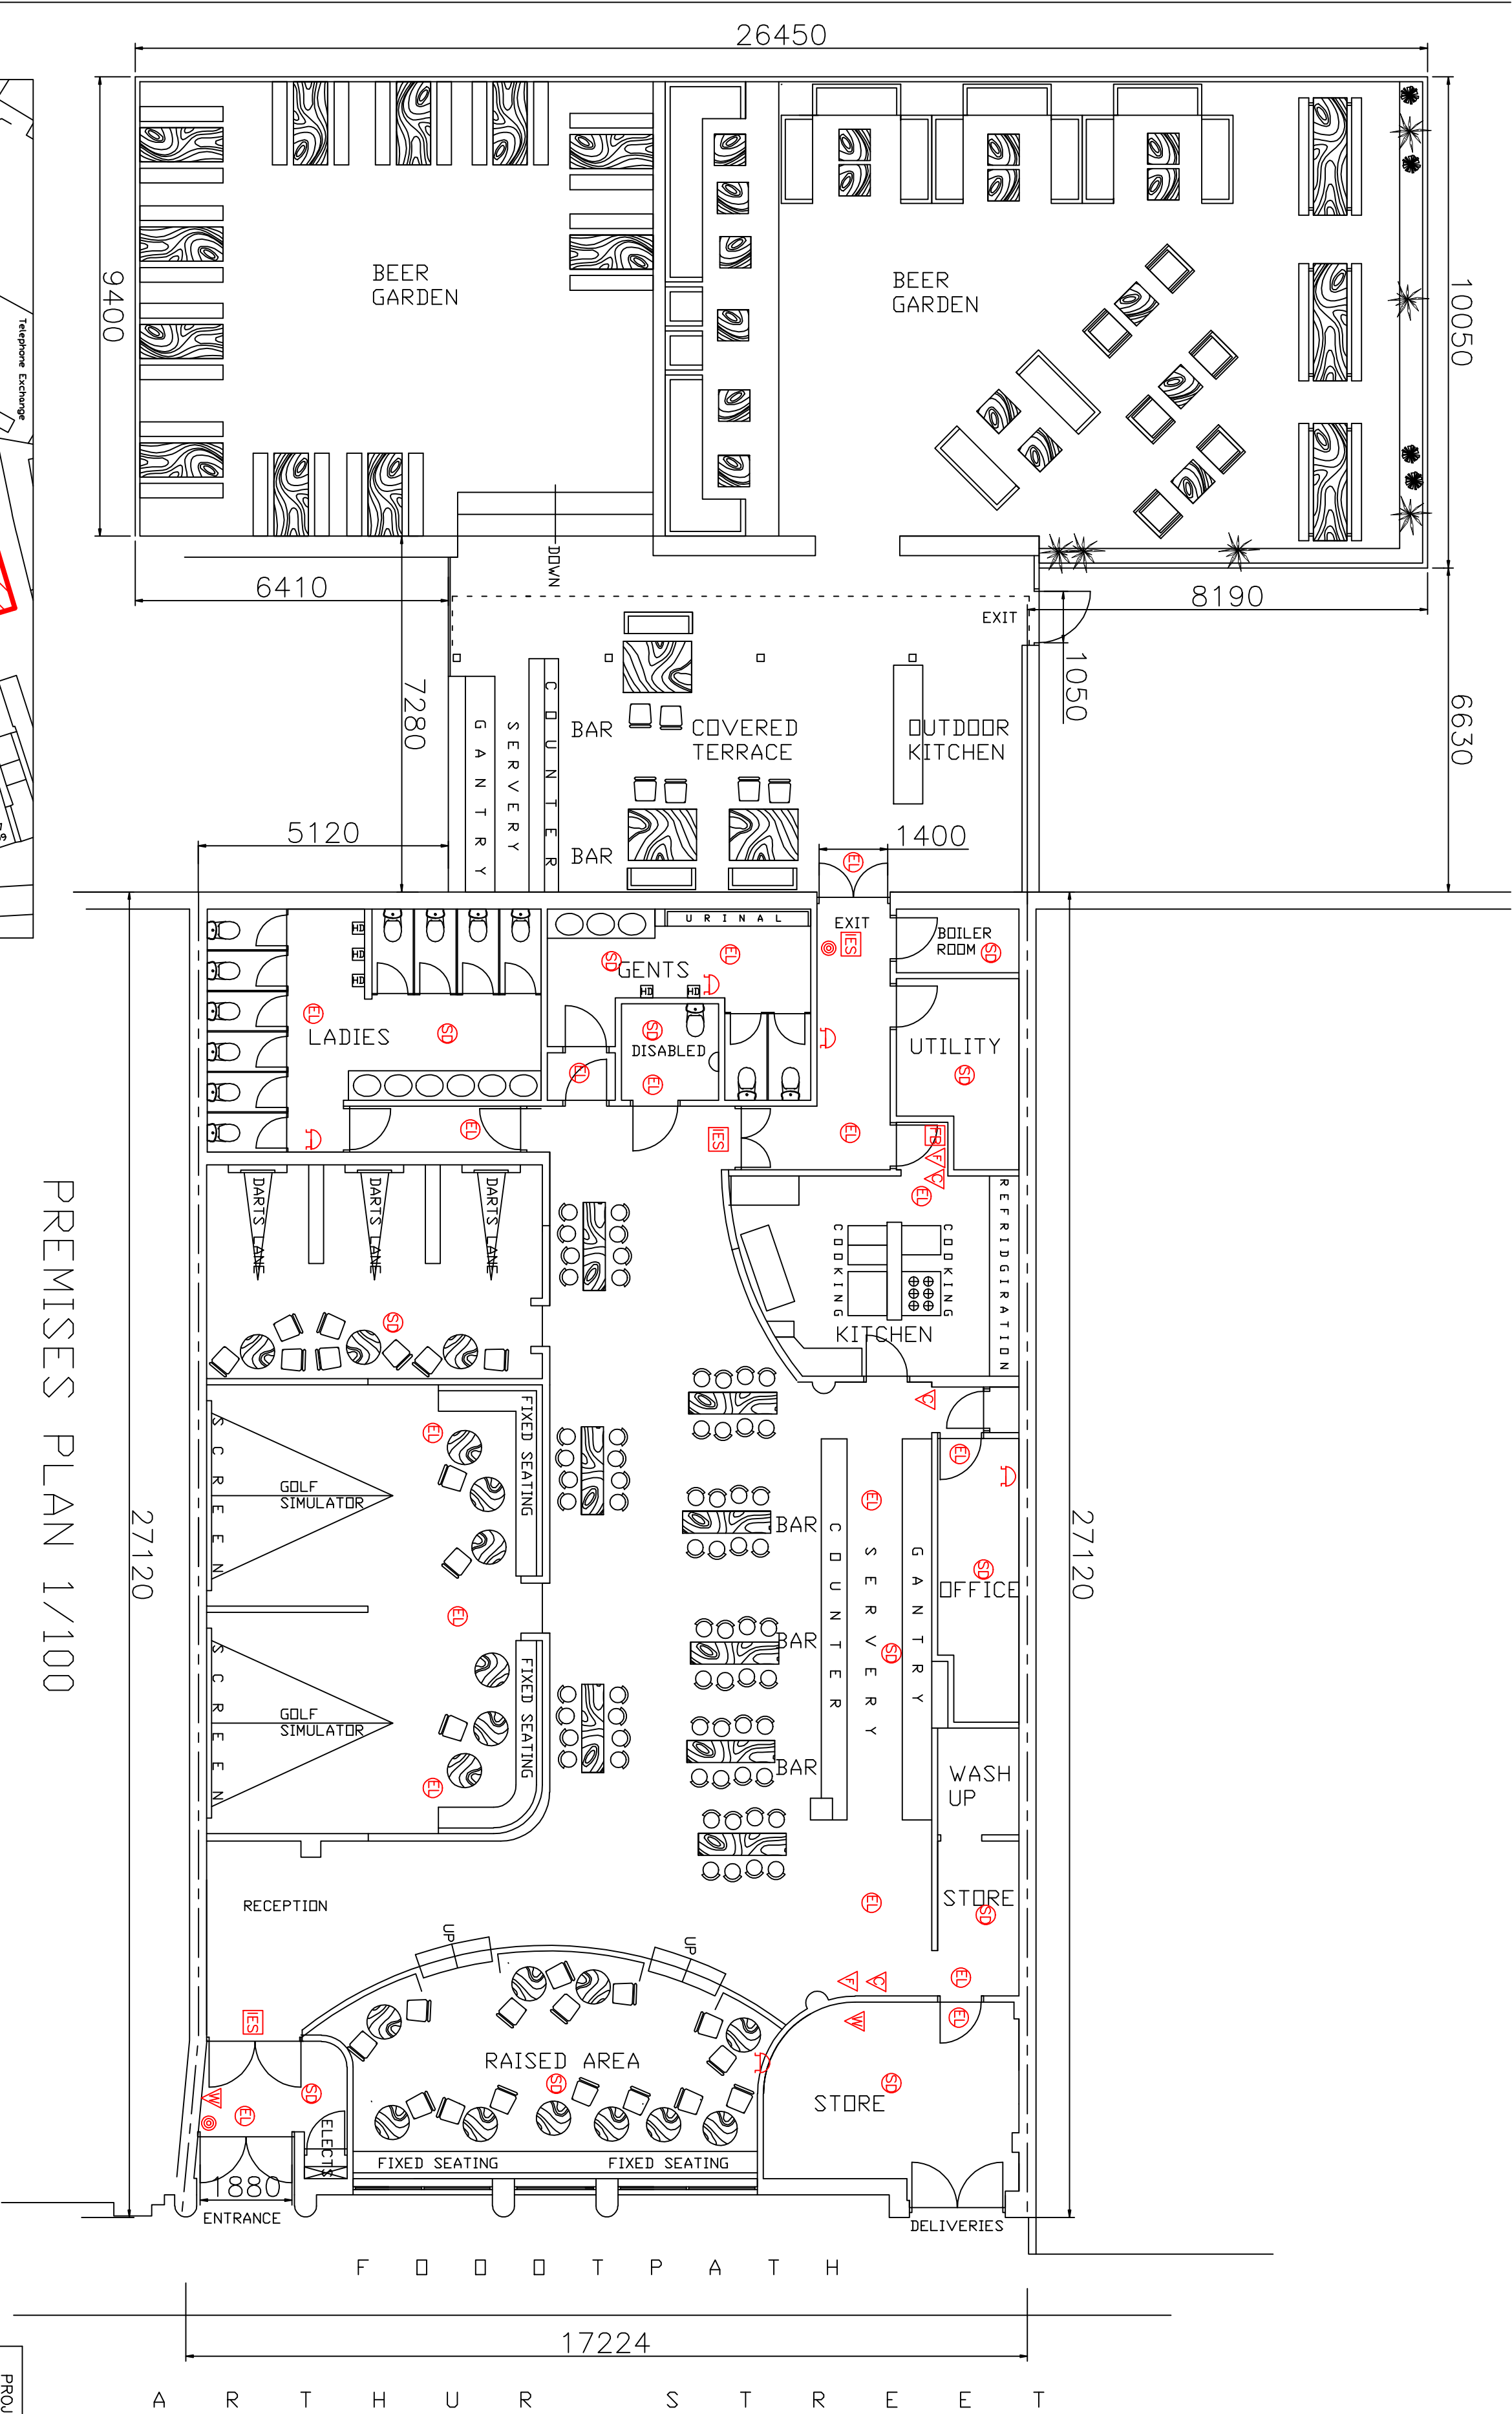

LOCATION PLAN 1/1250

PREMISES PLAN 1/100

PROJECT GOLF-X 11-13 ARTHUR STREET, AYR. KA7 1QU			
TITLE PREMISES PLAN			
SCALE 1/100 1/1250	FLOOR PLAN LOCATION PLAN		
DATE MARCH 2025	JOB NO. SH	DRG NO. 1	REV
Drawn by JAMES REID	Passed by J.R.	Issued for	

- FIRE FIGHTING / PREVENTION KEY
- GENERAL FIRE ACTION NOTICE
 - STAFF FIRE ACTION NOTICE
 - KEEP LOCKED SHUT NOTICE
 - EMERGENCY LIGHTING
 - SMOKE DETECTOR
 - HEAT DETECTOR
 - DRY POWDER EXTINGUISHER
 - FOAM EXTINGUISHER
 - WATER EXTINGUISHER
 - CARBON DIOXIDE EXTINGUISHER
 - FIRE BLANKET
 - FIRE ALARM CALL POINT
 - FIRE ALARM SOUNDER
 - ILLUMINATED EXIT SIGN