

Ground Floor Plan

**LEGEND**

- E Emergency Lighting
- Smoke Alarm
- Fire Extinguisher


Do not scale - if in doubt ask!

**Arctec Designs**  
 23 Dallas Place, Troon  
 Ayrshire, KA10 6JE  
 Tel:- 01292-319914  
 Mob:- 07900557838  
 arctecdesigns@gmail.com

Client	The Kirkmichael Arms		
Project	The Kirkmichael Arms - 3 Straiton Road, Kirkmichael, KA19 7PH		
Type	Licensing Plan		
Drawing	Ground Floor Plan		

Date	February 2011	Scale	1:100
Drawn By	SMcCR		- A3

Job Ref.	Drawing No.
<b>10/352</b>	<b>Licensing</b>

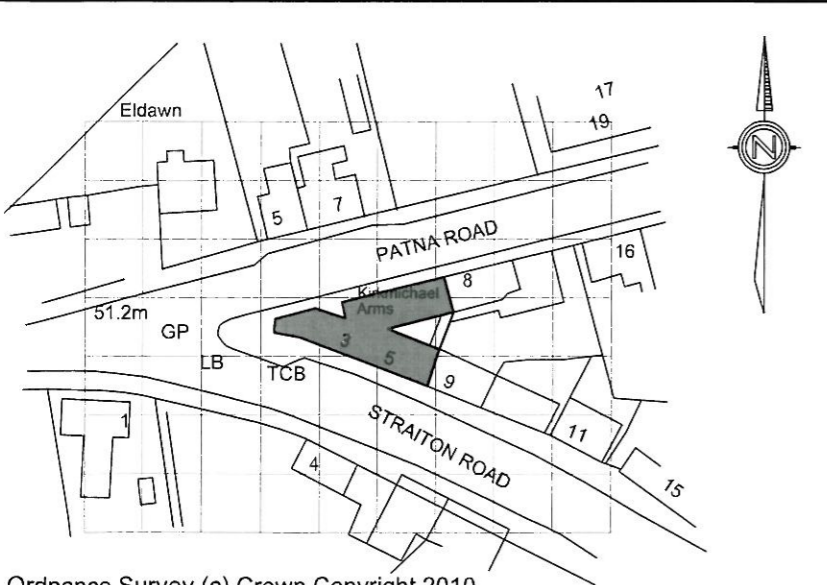

Ordnance Survey (c) Crown Copyright 2010.  
 All rights reserved. Licence number 100020449

Location Plan - Scale 1:1250

