


NO.	DESCRIPTION	DATE	BY

BLACK PEEBLES STREET

CROWN STREET

- KEY**
- BOUNDARY LINE
  - ⊕ VISIBLE ALCOHOL SALES PUMP
  - ~ LOCATION OF VISIBLE ALCOHOL SALES TOP + BOTTOM COUNTER
  - PROPOSED WORKS
  - NEW FIRE ESCAPE DOOR WITH ILLUMINATED SIGNATURE ABOVE TO BUILDING CONTROL STANDARDS

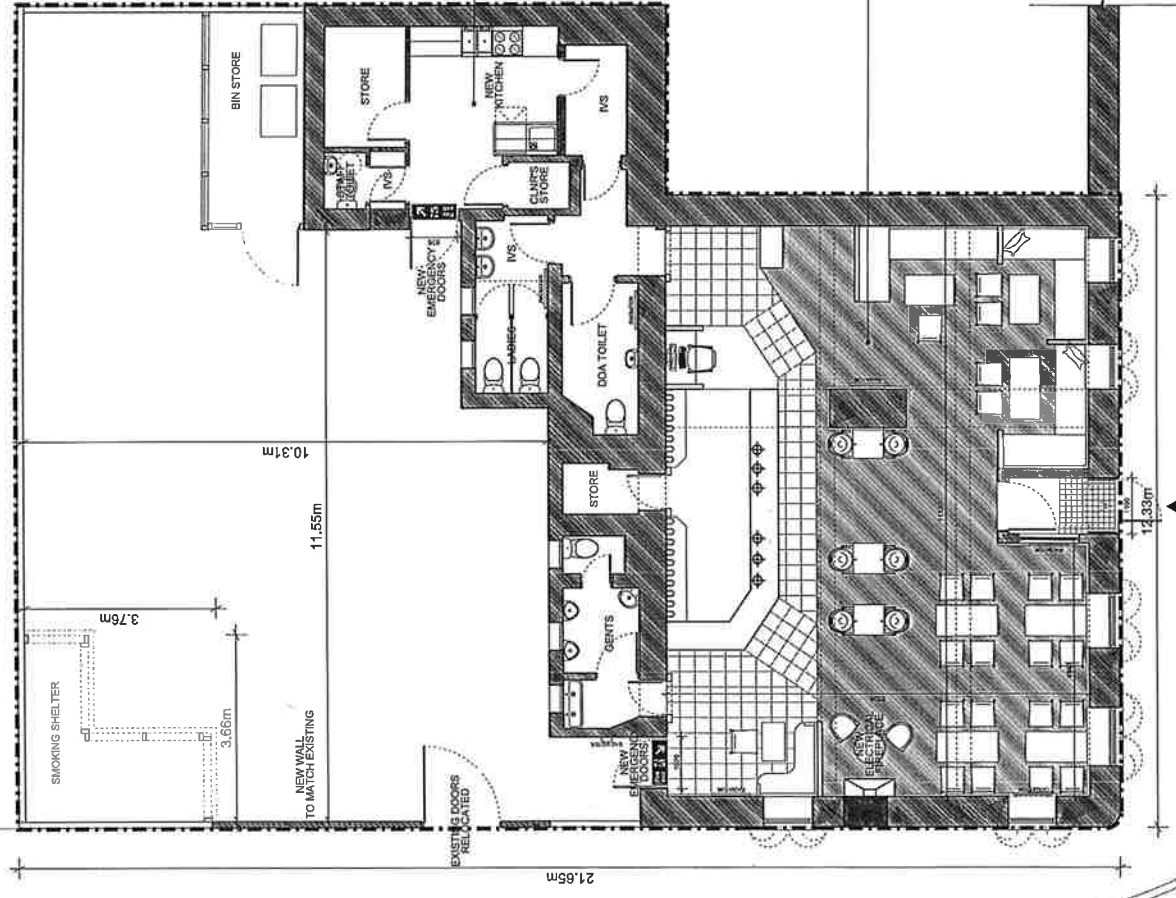

New fire, smoke and heat detection system to Building Control Standard and linked into existing fire alarm system

All existing fire detection/ alarm system to be retained

DRAWING STATUS  
**FOR INFORMATION**

FOR NEWTON ARMS

TITLE  
**GROUND FLOOR PLAN AS PROPOSED**

SCALE	DATE	DRAWN
1:100@A3	NOV 2012	DRAWN
DRG NO.	REVISION	
AL(01)02		
DRAWN BY: [NAME]		
PLOTTED BY: [NAME]		
SCALE: 1:100 @ A3		
AT STAGES		

GROUND FLOOR PLAN AS PROPOSED 1/100

DO NOT SCALE: WORK TO FIGURED DIMENSIONS ONLY