


Ground Floor Plan

LEGEND

	Emergency Lighting
	Smoke Alarm
	Fire Extinguisher

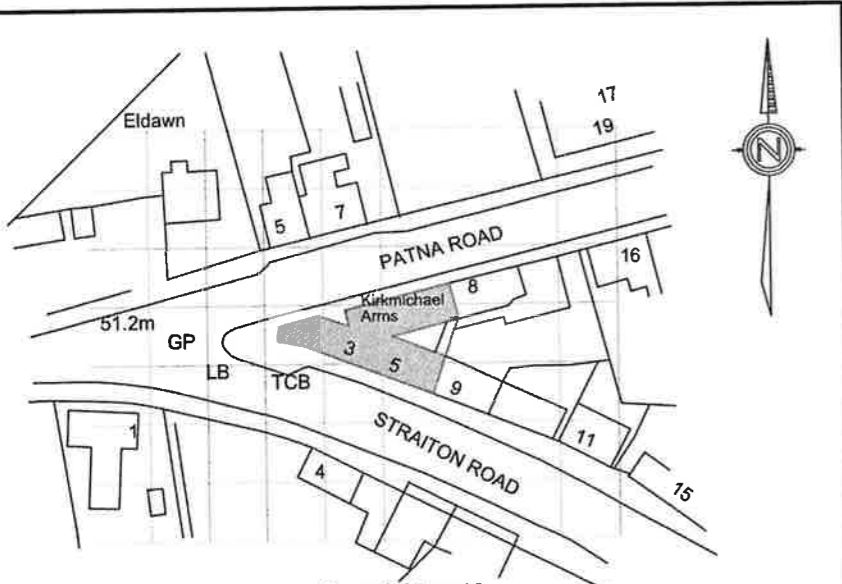

Ordnance Survey (c) Crown Copyright 2010.
 All rights reserved. Licence number 100020449
Location Plan - Scale 1:1250

Do not scale - if in doubt ask!

Arctec Designs
 23 Dallas Place, Troon
 Ayrshire, KA10 6JE
 Tel:- 01292-319914
 Mob:- 07900557838
 arctecdesigns@gmail.com

Client	The Kirkmichael Arms		
Project	The Kirkmichael Arms - 3 Straiton Road, Kirkmichael. KA19 7PH		
Type	Licensing Plan		
Drawing	Ground Floor Plan		

Date	March 2012	Scale	1:100
Drawn By	SMcCR		- A3
Job Ref.	Drawing No.		

10/352 **Licensing (d)**

