


Upper Floor Plan

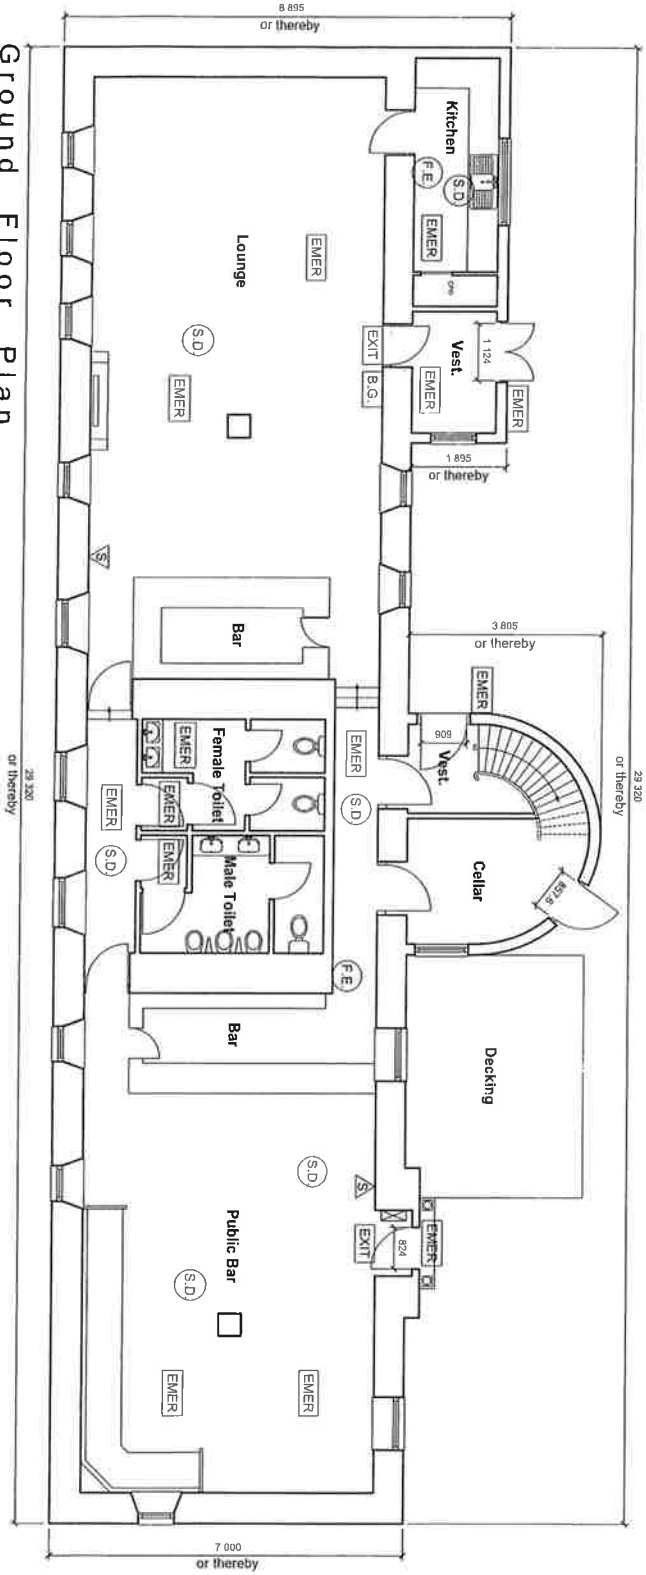

Ground Floor Plan

- LEGEND**
- ceiling mounted emergency light
 - ceiling or wall mounted escape light
 - wall mounted break glass point
 - smoke detector
 - ceiling or wall mounted sounder point
 - fire extinguisher
 - fire alarm system

Do not scale - if in doubt ask!

Constructive Architectural Design Ltd.	
Unit 2 Sharnall Estate Salford Tel: 0161 825 198 e-mail: constructive@btconnect.com	
Incorporating	
Arctec Designs	
Client	The Birch SUI
Address	Managership Street, Tipton
Project	DAE SFR
Drawn	Proposed Licensing
Date	October 2012
Drawn By	J.McCarthy
Scale	1:100
Job No	12/476
Drawing No	20

