


GROUND FLOOR PLAN 1/100

DRINKS DISPLAY LEGEND

- A 3800mm wide
750mm deep
1900mm high
- B 2650mm wide
400mm deep
2300mm high
- C 1250mm wide
400mm deep
2300mm high

This is the Layout Plan referred to in the application by Arif A Malik for variation of the Premises Licence for Toll Mini Mart, 157-159 Ayr Road Prestwick

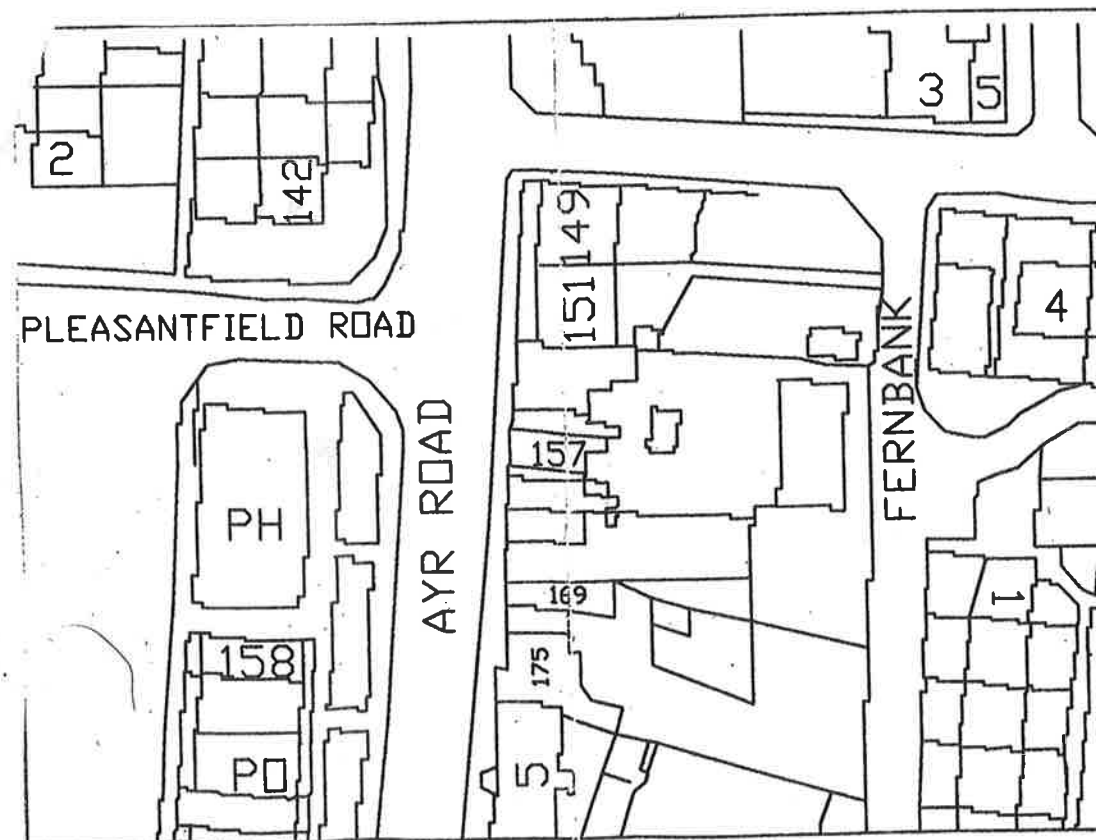

LOCATION PLAN

LEGEND

GENERAL FIRE ACTION NOTICE	N1
STAFF FIRE ACTION	N2
KEEP LOCKED SHUT NOTICE	N3
EMERGENCY LIGHTING	EL
SMOKE DETECTOR	SD
HEAT DETECTOR	HD
DRY POWDER EXTINGUISHER	VP
FOAM EXTINGUISHER	V
WATER EXTINGUISHER	W
CARBON DIOXIDE EXTINGUISHER	V
FIRE BLANKET	FB
FIRE ALARM CALL POINT	●
FIRE ALARM SOUNDER	⌒
ILLUMINATED EXIT SIGN	IES

PROJECT
TOLL MINI MARKET
157 AYR ROAD, PRESTWICK

TITLE
EXISTING PLANS

SCALE 1:100			
DATE 27/12/13	JOB NO.	DRG NO.	REV
Drawn by	Passed by	Issued for	