


First Floor Plan

LEGEND

	Emergency Lighting
	Smoke Detector
	O.S.
	Elevator
	Staircase
	Bath Glass
	Mechanical Extractor Fan

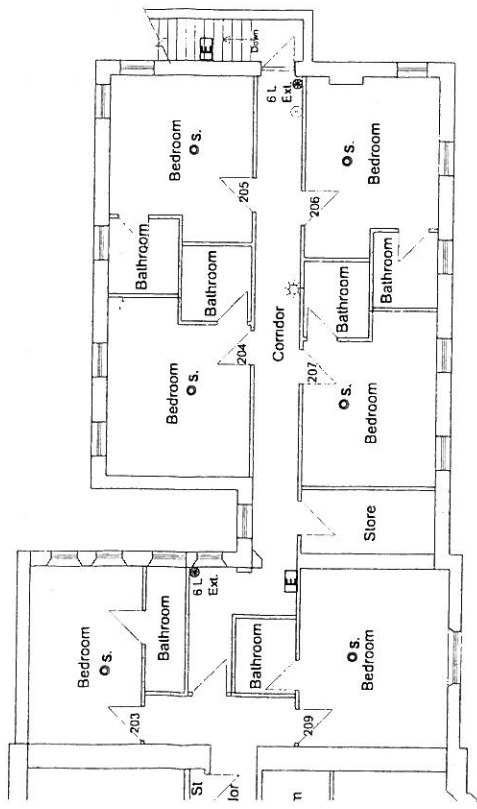


08/24/2008 11:56:02 AM

**Arctec Designs**  
 17000 14th Street  
 Anchorage, Alaska 99503  
 Tel: 907.562.1234  
 Fax: 907.562.1234  
 Email: info@arctecdesigns.com


**Constructive Architectural Design Ltd**  
 10000 14th Street  
 Anchorage, Alaska 99503  
 Tel: 907.562.1234  
 Fax: 907.562.1234  
 Email: info@constructivearchitectural.com

Client	The South Beach Hotel
Project	17000 14th Street
Project	17000 14th Street
Type	Learning Drawing
Drawing	First Floor Plan
Date	May 2008
Drawn By	Diagram Machine
Scale	1:100
Job Ref	
Drawing No.	

08/213 - 02

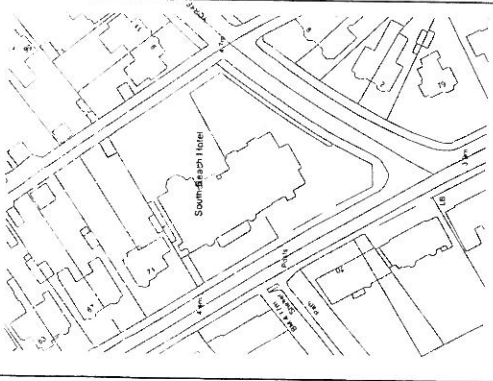

Location plan 1:1250

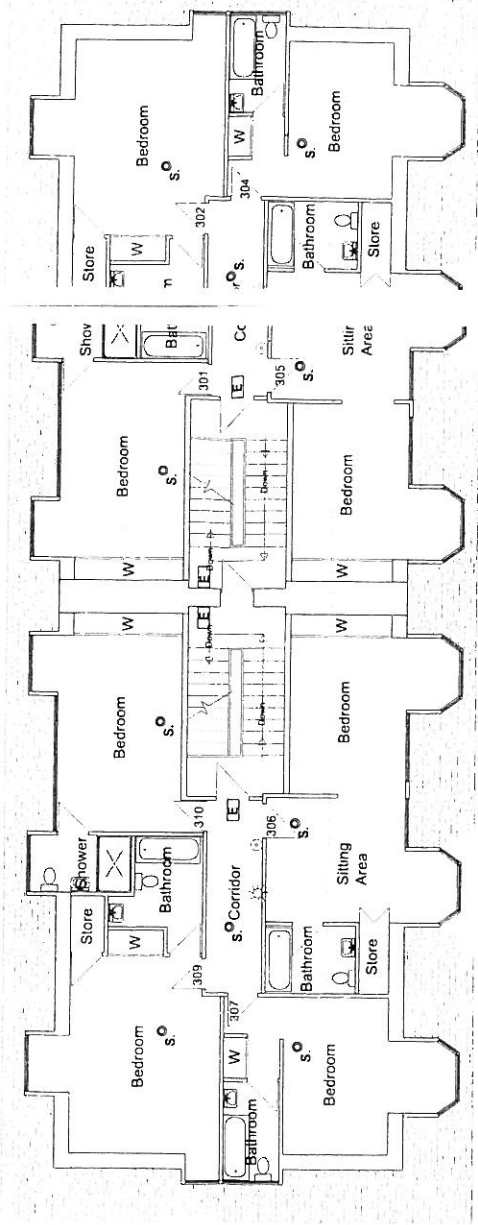

Second Floor Plan

LEGEND

LE	Emergency Lift
OS	Open Storage
⊗	Emergency
☼	Shower
⊕	Break Glass
⊞	Microfilm Terminal

Scale: 1:1000  
 Date: May 2008  
 Drawn by: Sheena McCune  
 Checked by: J.C. Pfr  
 Drawing No.: 08/213 -03

**Arctec Designs**  
 23 Danks Place, Dublin  
 Tel: +353 1 232 3374  
 Fax: +353 1 232 3375  
 Email: info@arctecdesigns.com, sales@arctecdesigns.com

**Constructive Architectural Design Ltd**  
 44, Upper Mount Street, Dublin  
 Tel: +353 1 4754 5214  
 Fax: +353 1 4754 5215  
 Email: info@constructivead.com, sales@constructivead.com

Client:	The South Beach Hotel
Project:	Phase 2A USBC Hotel
Type:	Architectural Drawing
Drawing:	Second Floor Plan