


This drawing is the property of the CF Technical Services. Copyright is reserved by them and the drawing is issued on the condition that it is not copied, reproduced, retained or disclosed to any unauthorised person, either wholly or in part without the consent in writing of the CF Technical Services.

N.B. any variations between stated dimensions and site dimensions should be reported prior to work being executed.

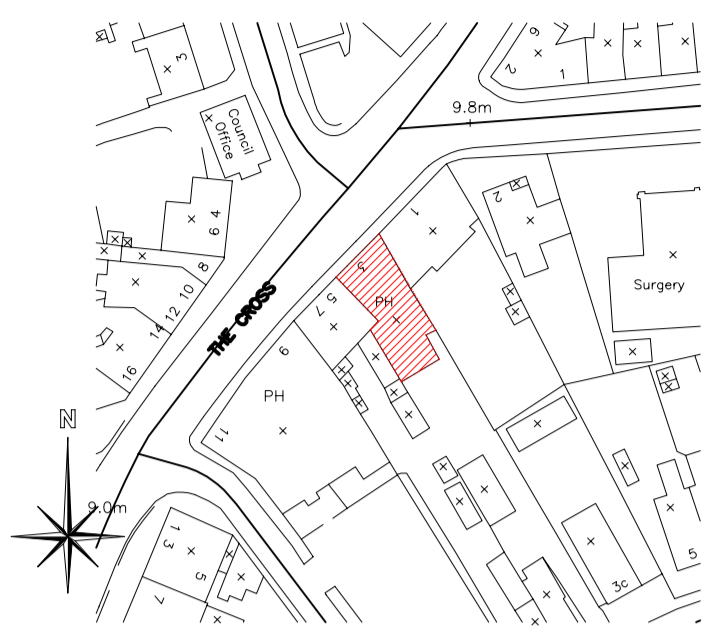


**LOCATION PLAN**  
**SCALE 1:1250**

Schedule of additional information	
Number of Storeys	1
Staff Accommodation	0
Letting room with mini bar	0
Letting room without minibar	0
Dance Area	None
Live music	None
Fire Alarm	No
Children licensed area	No
Outdoor drinking area	Yes
Off Sales	None

- CEILING HEIGHT
- EMERGENCY EXIT LIGHT
- EMERGENCY EXIT SIGN
- SMOKE DETECTOR
- HEAT DETECTOR
- FIRE EXTINGUISHER CO
- FIRE EXTINGUISHER FOAM
- FIRE EXTINGUISHER WATER
- FIRE EXTINGUISHER POWDER
- BREAK GLASS CALL POINT
- KLAXON FIRE SOUNDER

Hatch denotes area accessible to children when accompanied by an adult. Hatch denotes outside drinking area.

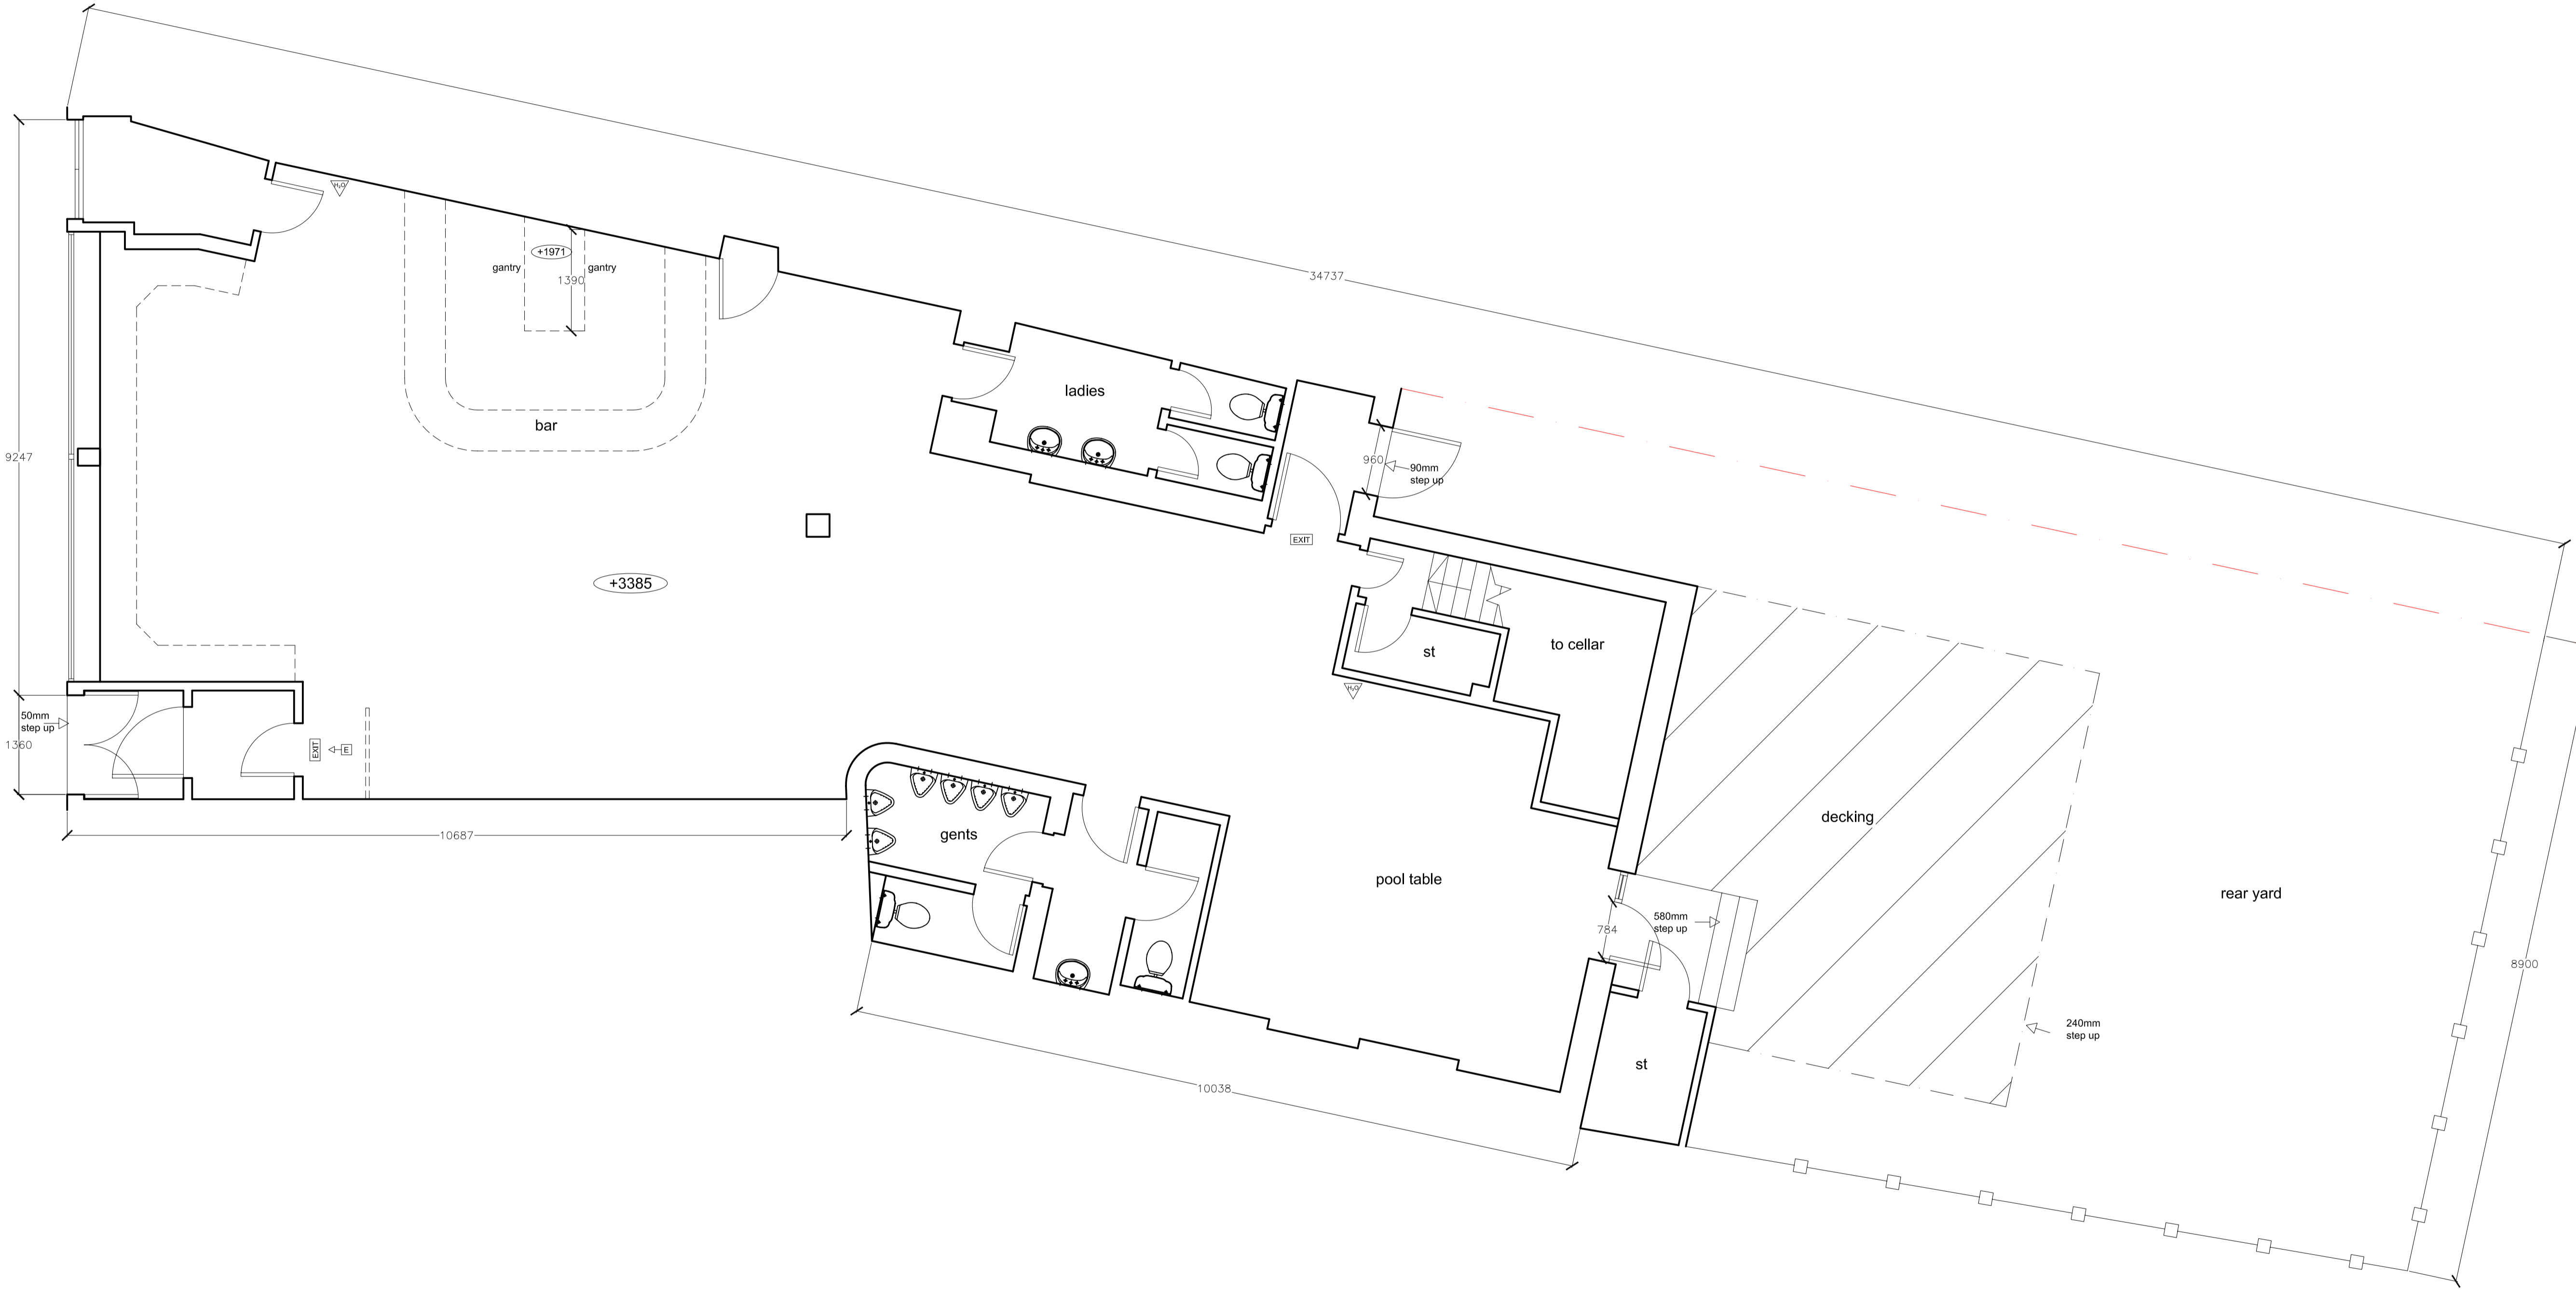

Ref	Date	Revision	By

Client: **SCOTTISH AND NEWCASTLE**

Project: **EAGLE TAVERN  
3/5 THE CROSS  
PRESTWICK  
KA9 1AJ**

Title: **FLOOR PLAN**

Drawing No:	Rev:	Scale:
EAGLE TAVERN-LP-01		A1-1:50

Date:	Drawn by:	Checked by:
DEC 2007	CC	DF

**CF Technical Services Ltd**

The Clarendon Centre  
112 Cornwall Street South  
Glasgow  
G41 1AA  
Tel : 0141 427 4741  
Fax : 0871 990 6330  
e-mail : david@cftechnicalservices.co.uk