



THE LOANING STORES

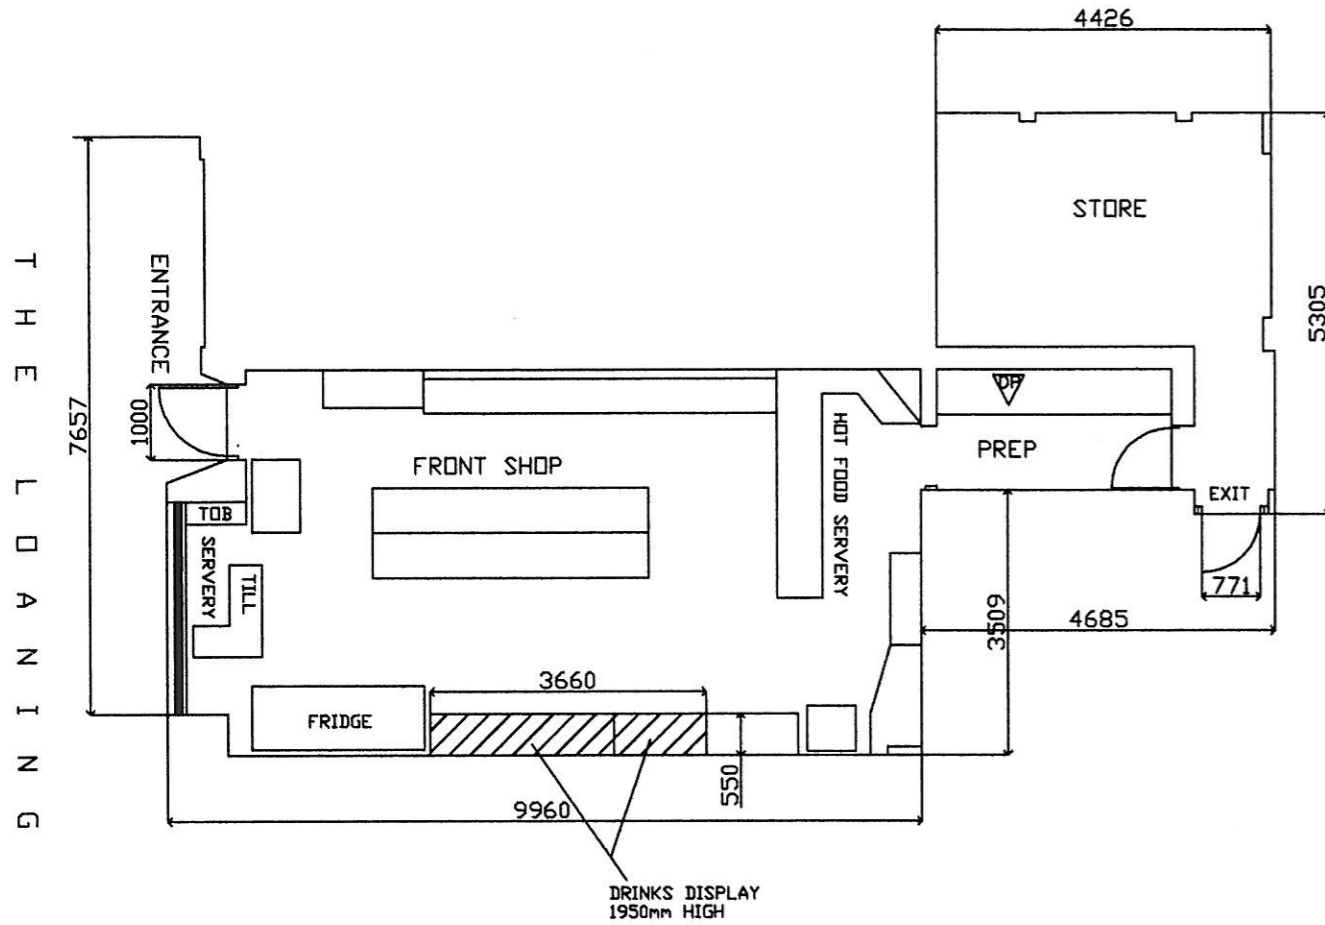

EXISTING GROUND FLOOR PLAN 1/100

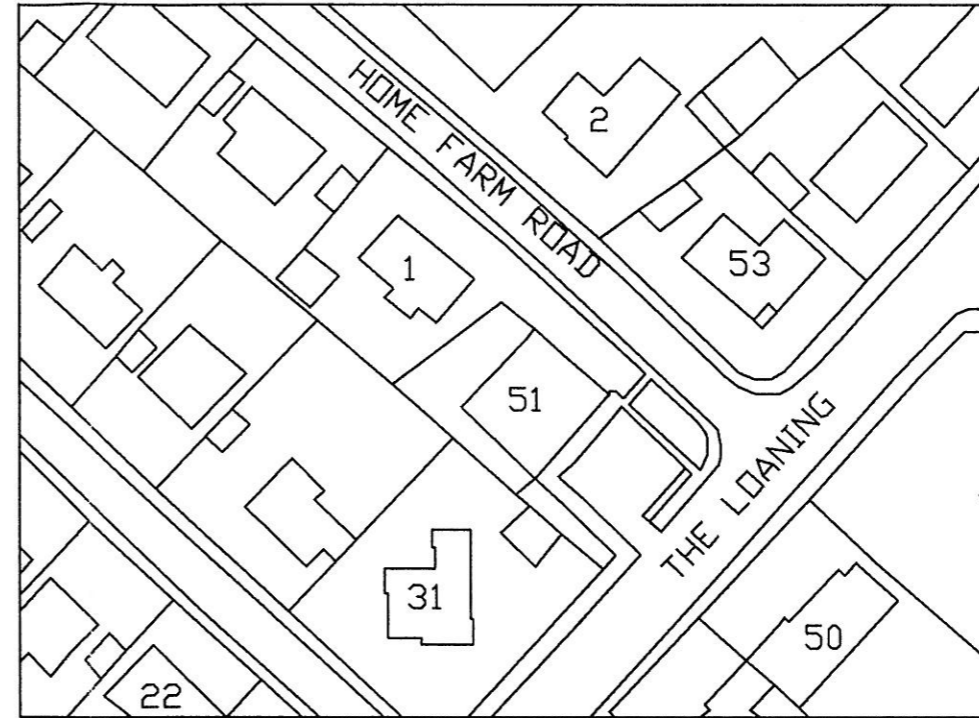

LOCATION PLAN

LEGEND

- GENERAL FIRE ACTION NOTICE N1
- STAFF FIRE ACTION N2
- KEEP LOCKED SHUT NOTICE N3
- EMERGENCY LIGHTING EL
- SMOKE DETECTOR SD
- HEAT DETECTOR HD
- DRY POWDER EXTINGUISHER VP
- FOAM EXTINGUISHER VF
- WATER EXTINGUISHER VW
- FIRE BLANKET FB
- FIRE ALARM CALL POINT CP
- FIRE ALARM SOUNDER AS
- ILLUMINATE EXIT SIGN IES
- CARBON DIOXIDE EXTINGUISHER VCD
- DRINKS AREA
- ATM MACHINE

PROJECT
THE LOANING STORES
51 THE LOANING

TITLE
EXISTING FLOOR PLANS

J. REID
ARCHITECTURAL SERVICES

197 MAIN ST
PRESTWICK
KA9 1LH
Tel.: 01292 470331

SCALE 1:100			
DATE 27/02/08	JOB NO.	DRG NO.	REV
DRAWN BY JOHN REID			