

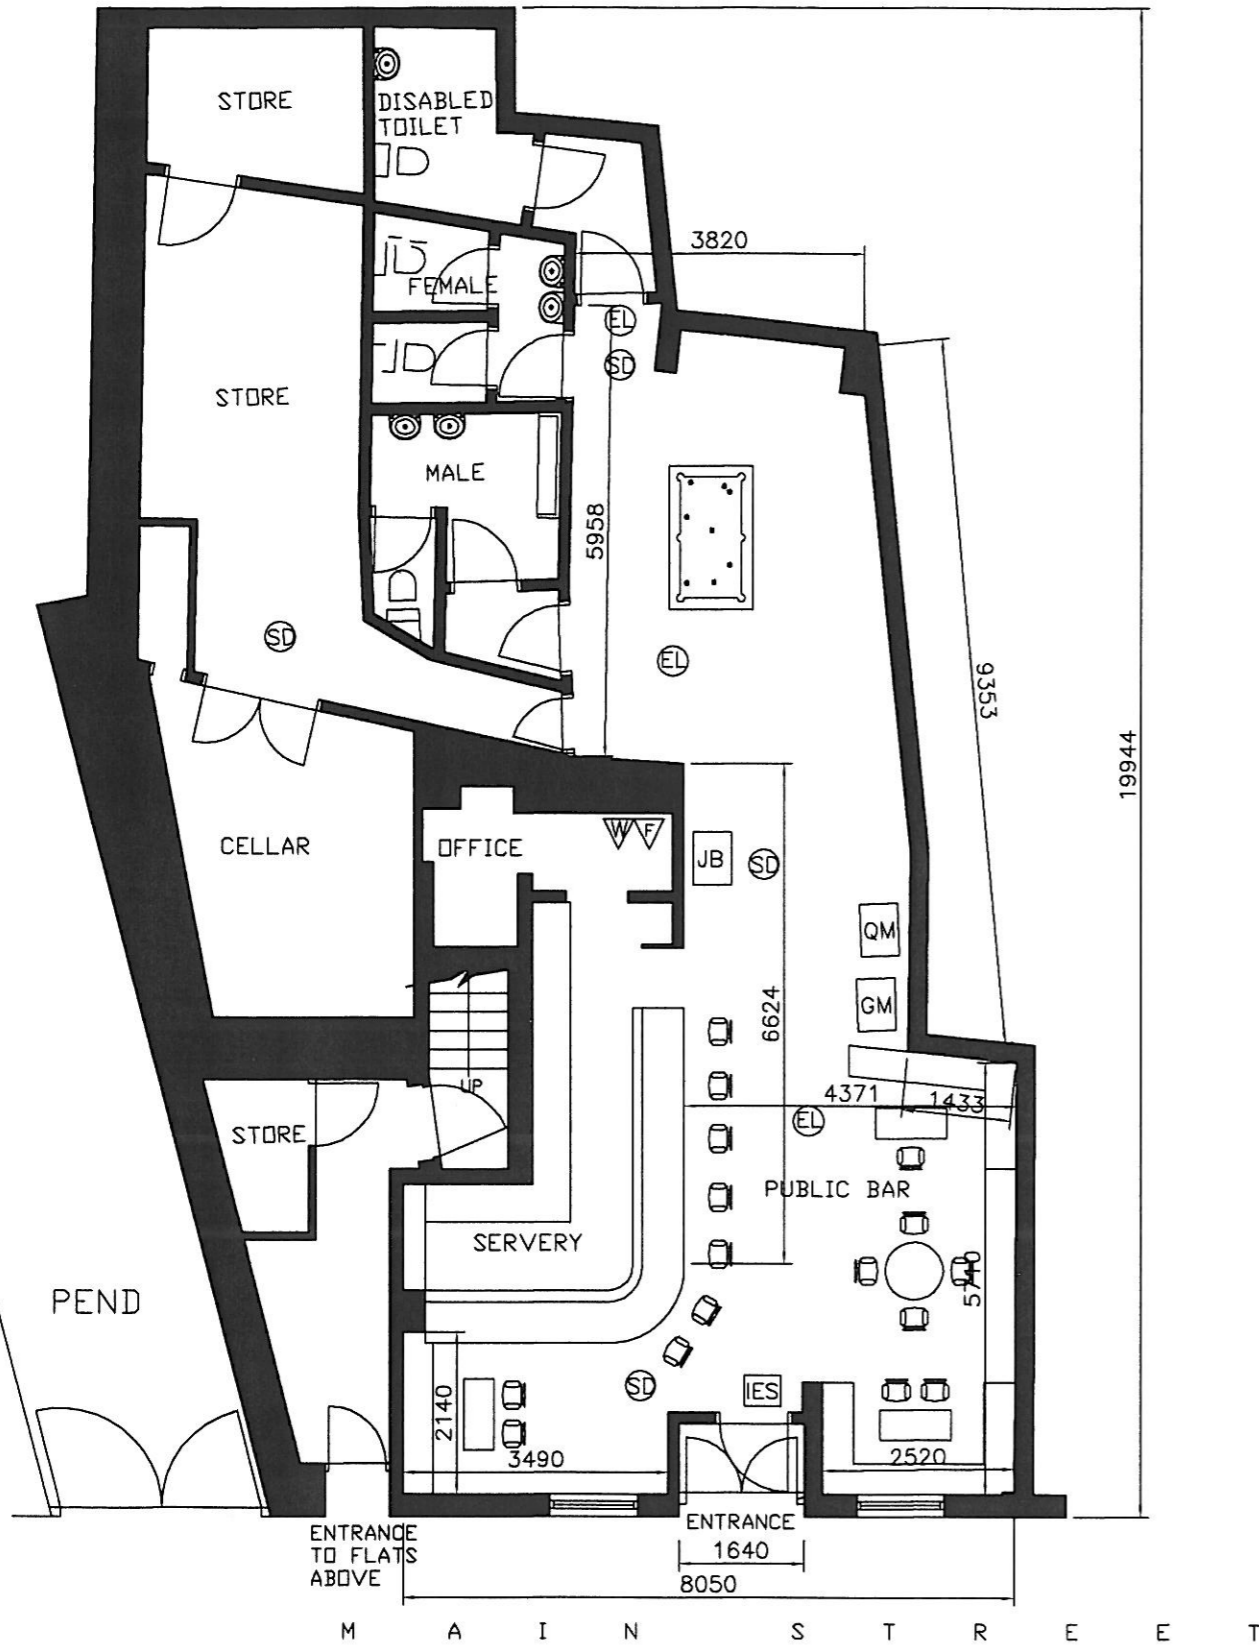


# SMUGGLERS, MAIN STREET, PRESTWICK.

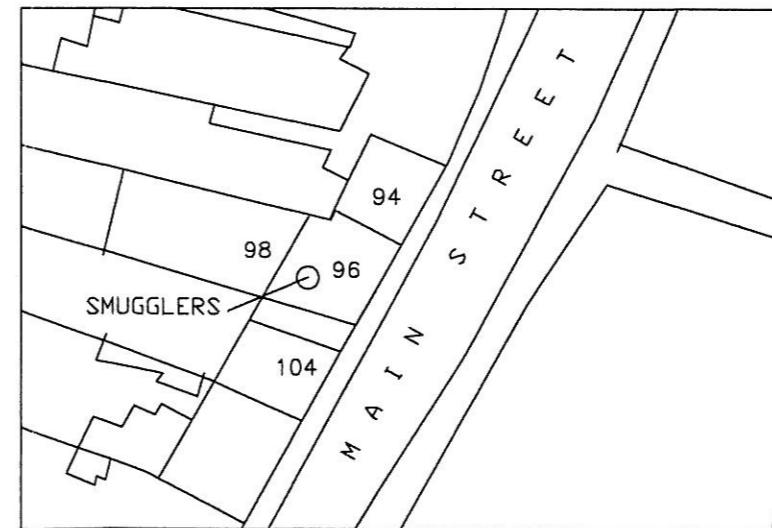

EXISTING FIRST FLOOR PLAN 1/100

FLOOR AREA OF PUBLIC BAR  
= 61.42m<sup>2</sup>

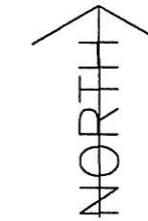

LOCATION PLAN

## LEGEND

- GENERAL FIRE ACTION NOTICE N1
- STAFF FIRE ACTION N2
- KEEP LOCKED SHUT NOTICE N3
- EMERGENCY LIGHTING EL
- SMOKE DETECTOR SD
- HEAT DETECTOR HD
- DRY POWDER EXTINGUISHER ▽
- FOAM EXTINGUISHER ▽
- WATER EXTINGUISHER ▽
- FIRE BLANKET FB
- FIRE ALARM CALL POINT JD
- FIRE ALARM SOUNDER ∩
- ILLUMINATE EXIT SIGN IES
- CARBON DIOXIDE EXTINGUISHER ▽
- GAMING MACHINE GM
- JUKEBOX JB
- QUIZ MACHINE QM

PROJECT  
SMUGGLERS BAR,  
MAIN ST, PRESTWICK

TITLE  
EXISTING FLOOR PLANS

**J. REID & SON**  
ARCHITECTURAL SERVICES

197 MAIN ST  
PRESTWICK  
KA9 1LH  
Tel.: 01292 470331



SCALE	1:100		
DATE	JOB NO.	DRG NO.	REV
21/01/08			
Drawn by	Passed by	Issued for	
JAMIE REID			