

LAYOUT PLAN 1:100

- EL EMERGENCY LIGHT
- ⊕ SA SMOKE ALARM
- HD HEAT DETECTOR
- FIRE ALARM BREAK GLASS - see location
- FIRE ALARM PANEL - see location
- FEF FIRE EXTINGUISHER - FOAM
- FEW FIRE EXTINGUISHER - WATER
- FECO2 FIRE EXTINGUISHER - CO2
- FB FIRE BLANKET

ALCOHOL DISPLAY

LENGTH OF BAR ——— 2600 mm
 HEIGHT OF BAR ——— 1200 mm

ALCOHOL DISPLAY - LOW LEVEL


LENGTH ——— 2600 mm
 HEIGHT ——— 1000 mm
 DEPTH ——— 500 mm

ALCOHOL DISPLAY - HIGH LEVEL


LENGTH ——— 850 mm
 HEIGHT ——— 2400 mm
 DEPTH ——— 300 mm

LAYOUT PLAN
 LICENSED RESTAURANT AT:
 26A WELLINGTON SQUARE
 AYR KA7 1HH

drg. no. 2

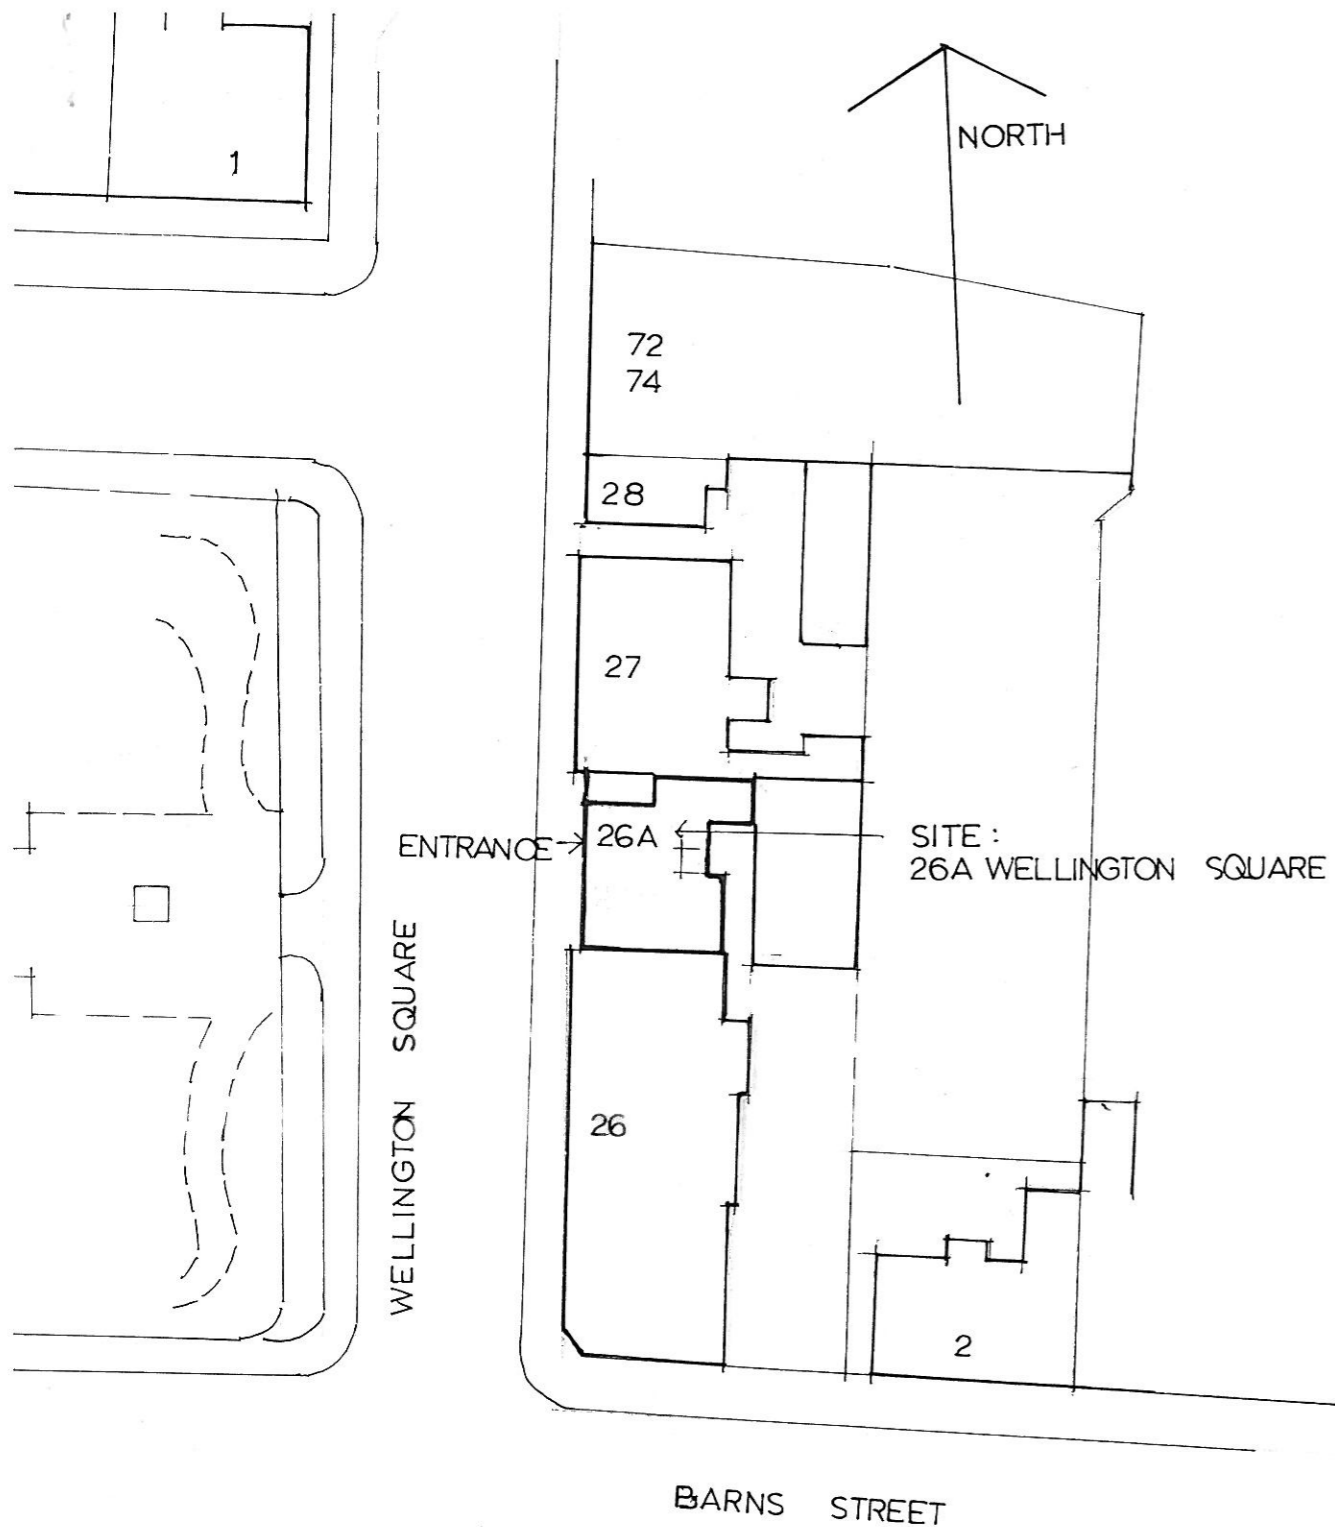

SITE PLAN 1:500

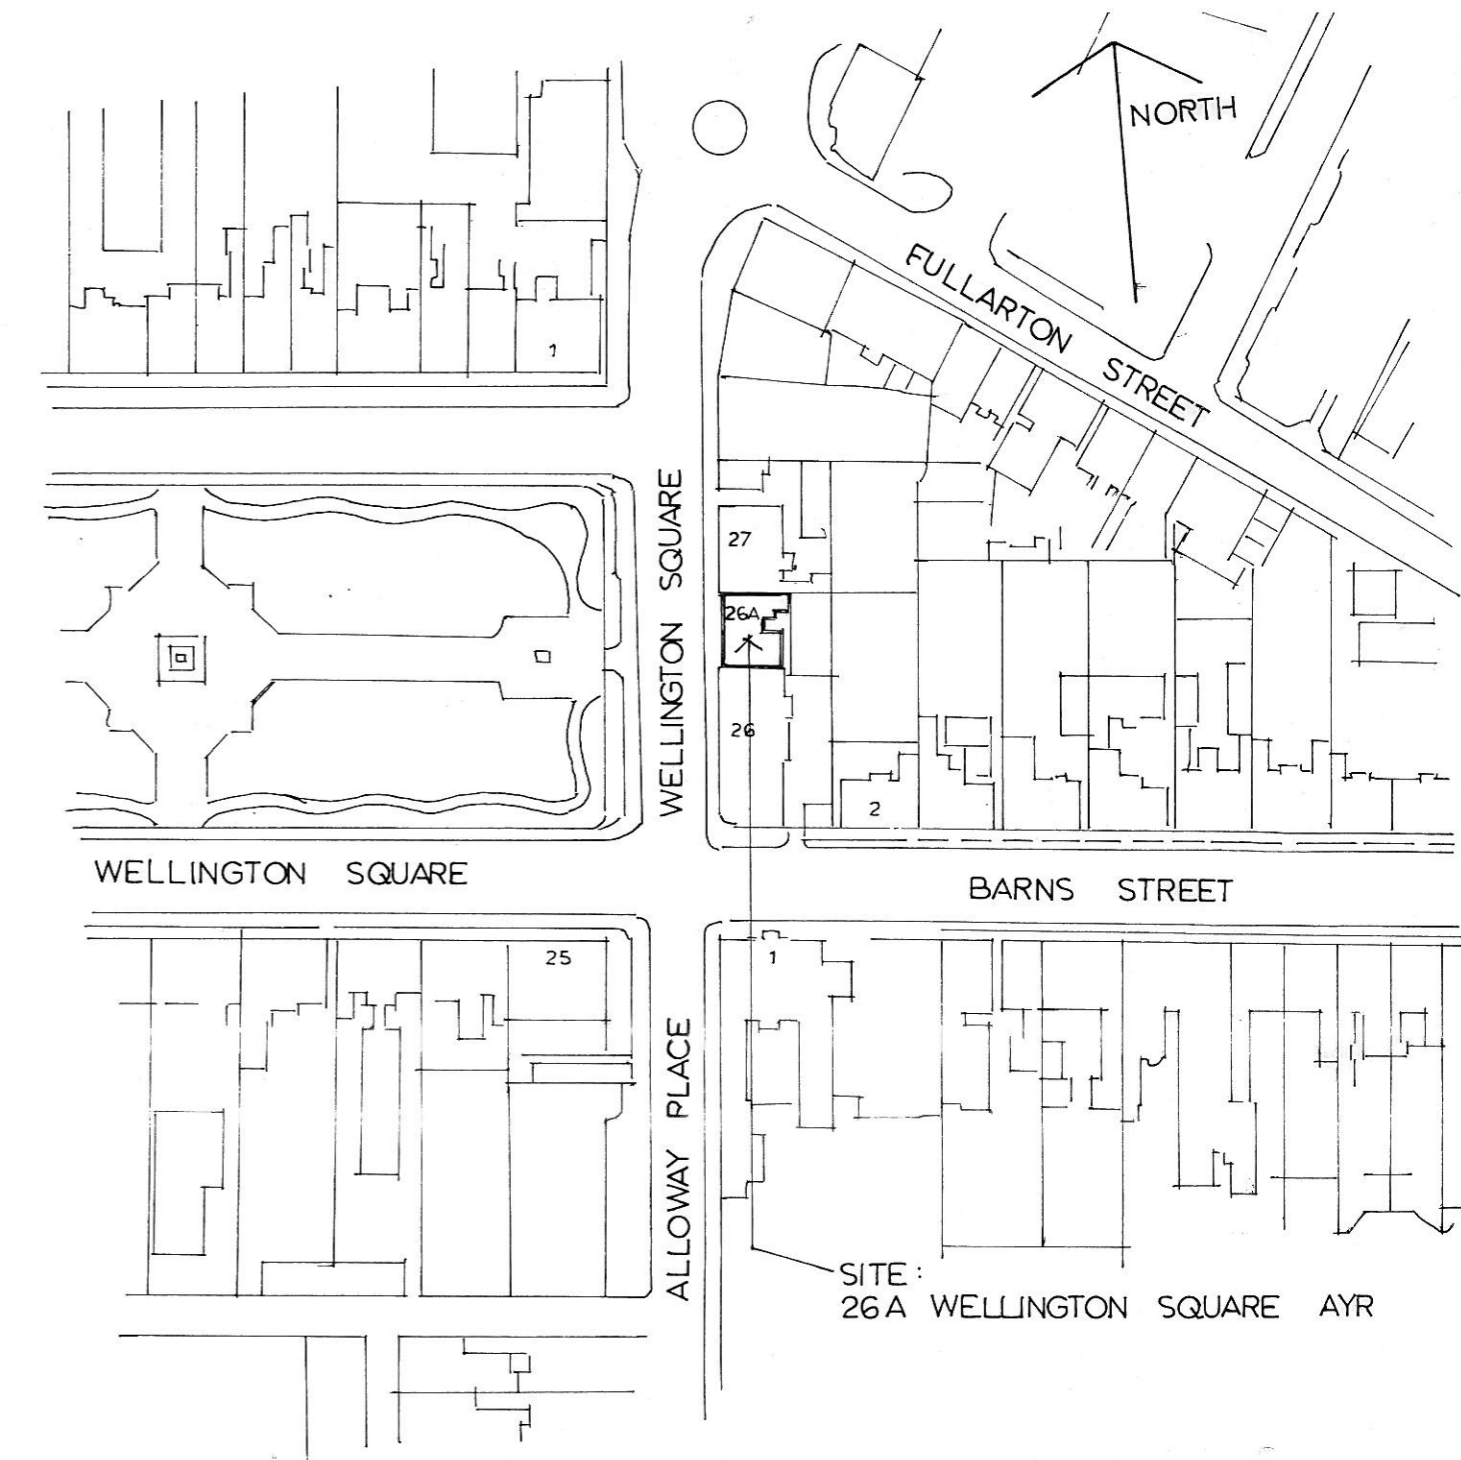

LOCALITY PLAN : 1:1250

LAYOUT PLAN
 LICENSED RESTAURANT AT:
 26A WELLINGTON SQUARE
 AYR KA7 1HH