
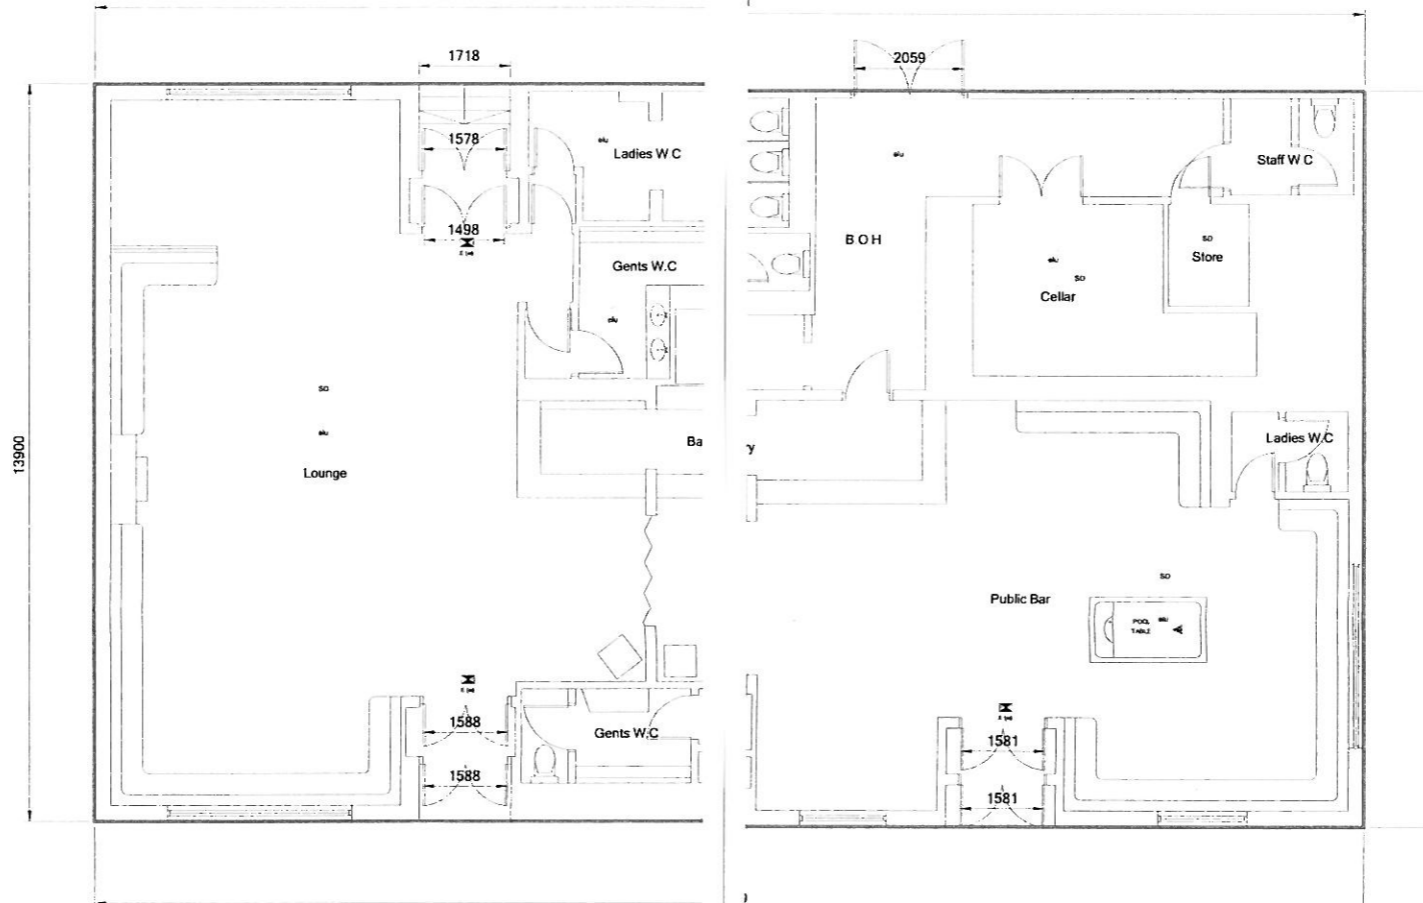


 Red Outline Delineates Licensed Area

 Green Outline Delineates Childrens Area And Access Route







Ground Floor Layout Plan As Existing



Scale : 1/1250

Key to Fire Warning System

- elu Emergency lighting unit
-  Directional Emergency lighting unit (maintained)
- E (m) Sounder device
-  Extinguisher 9L H2O
-  Extinguisher 2kg CO2
-  Extinguisher Dry Powder
- BG Break glass fire alarm point
- SD Smoke Detector
- S Sounder
- FB Fire Blanket

Toll Bar, Edinburgh	PUBLIC BAR	LOUNGE BAR	SEPERATE FUNCTION ROOM
Conference Facilities	No	Yes	N/A
Bar Meals	Yes	Yes	N/A
Restaurant Facilities	No	No	N/A
Club or Group Meeting	Yes	Yes	N/A
Recorded Music	Yes	Yes	N/A
Live Performances	Yes	Yes	N/A
Dance Facilities	No	No	N/A
Gaming	Yes	Yes	N/A
Indoor / Outdoor Sports	Yes	Yes	N/A
Televised Sport	Yes	Yes	N/A
Quiz Nights / Charity Events	Yes	Yes	N/A
Theatre	No	No	N/A
Films	No	No	N/A
Adult Entertainment	No	No	N/A
Receptions	No	Yes	N/A

This is the layout plan relative to the premises licence application dated 30 September 2008 on behalf of Iona Pub Partnership Ltd
 Toll Bar, 144 Ayr Road, Prestwick, KA9 1TS
 R & J M Hill Brown & Co

Rev	Date	Details	By	Rev	Date	Details	By	Notes
								Any information contained in this drawing which is not required by regulation 5 of SSI 2007/452 is included for illustrative purposes only and does not form part of the layout plan for purposes of the said regulation or the Licensing (Scotland) Act 2005

Drawing No	Drawing title Toll Bar	Scale 1:100 @ A2	IONA PUB PARTNERSHIP Virginia House 62 Virginia Street Glasgow G1 1TX
Project address	144 Ayr Road, Prestwick	Date July 2008	
Client		Drawn by K.McPhillips	
TOTAL occupancy = 372 PERSONS		GANTRY DIMENSIONS BAR / LOUNGE :- gantry 3865mm (Long) x 900mm (High) x 200mm (Deep)	