 




DRINKS DISPLAY 

- A 2600mm WIDE 2400mm HIGH
- B 1250mm WIDE 2300mm HIGH
- C 1370mm WIDE 1800mm HIGH
- D 1840mm WIDE 1800mm HIGH

 
 
 


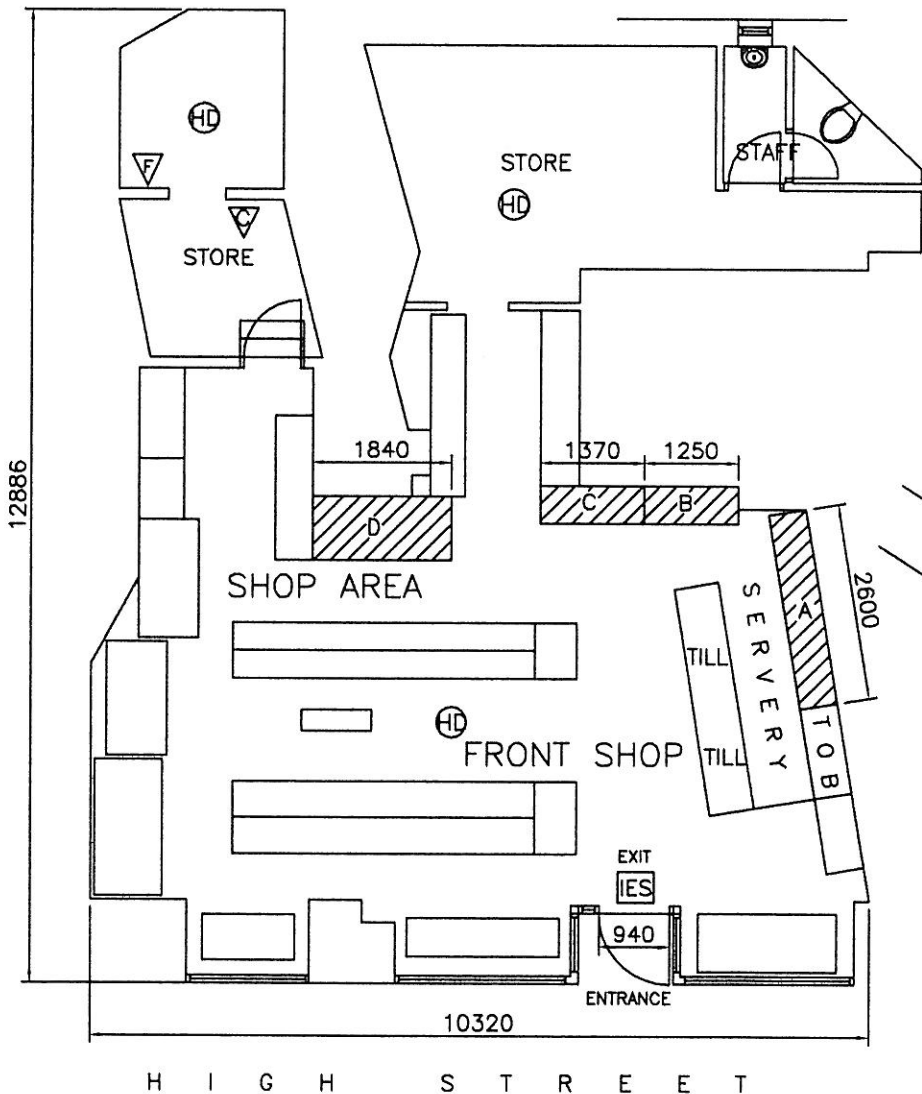

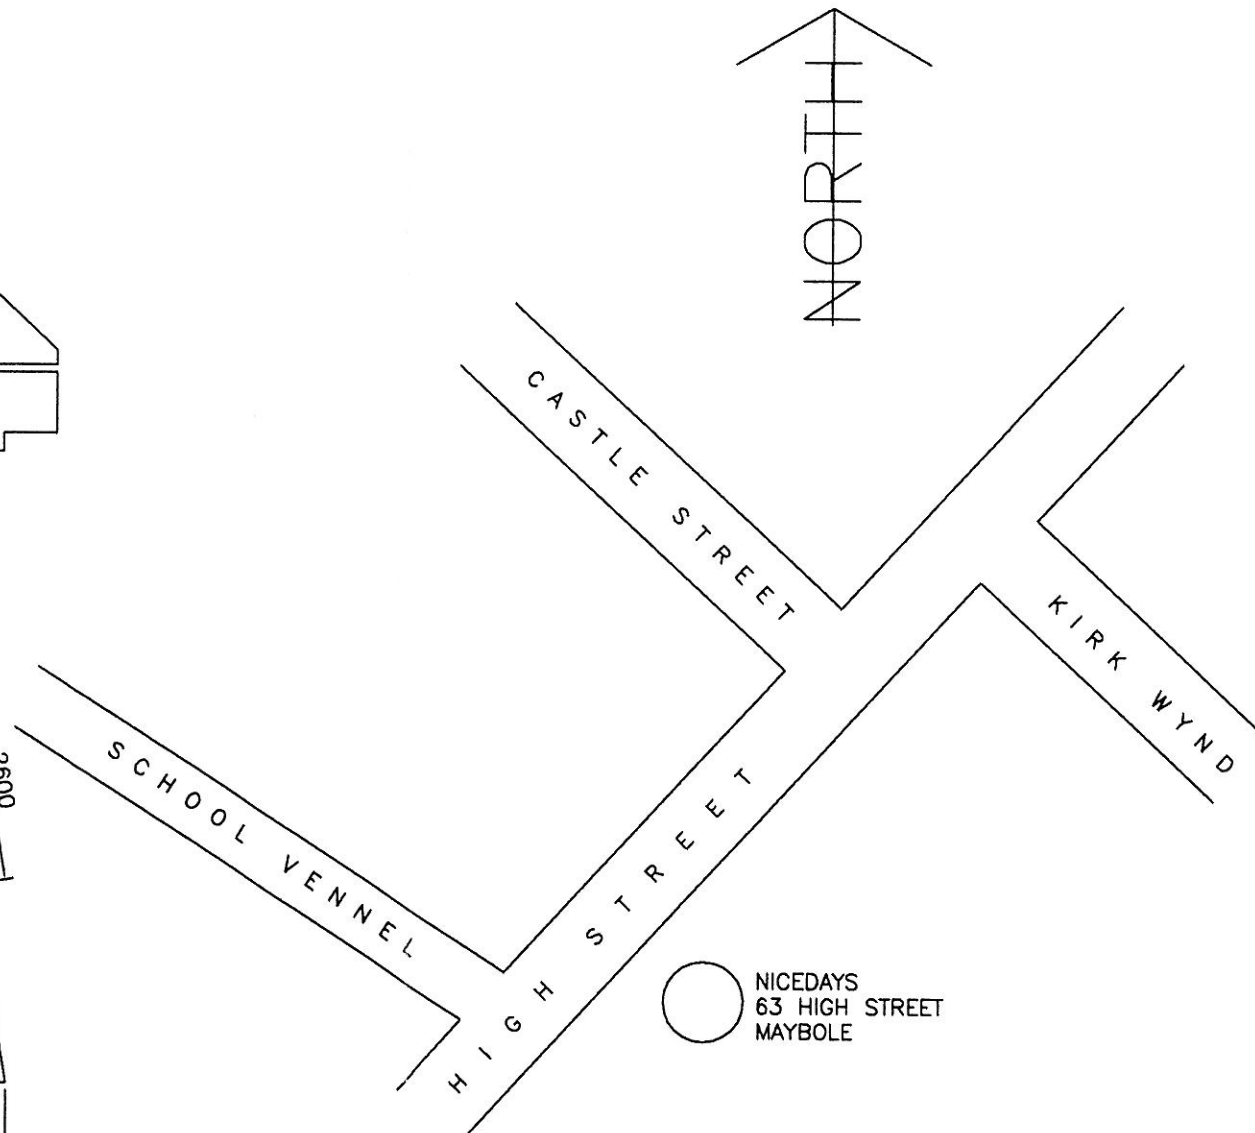









GROUND FLOOR PLAN 1/100



LOCATION PLAN

LEGEND

- GENERAL FIRE ACTION NOTICE 
- STAFF FIRE ACTION 
- KEEP LOCKED SHUT NOTICE 
- EMERGENCY LIGHTING 
- SMOKE DETECTOR 
- HEAT DETECTOR 
- DRY POWDER EXTINGUISHER 
- FOAM EXTINGUISHER 
- WATER EXTINGUISHER 
- CARBON DIOXIDE EXTINGUISHER 
- FIRE BLANKET 
- FIRE ALARM CALL POINT 
- FIRE ALARM SOUNDER 
- ILLUMINATED EXIT SIGN 
- CASH MACHINE 

PROJECT
NICEDAYS 63 HIGH STREET
MAYBOLE

TITLE
EXISTING PLANS

JAMES REID
ARCHITECTURAL SERVICES

197 MAIN ST
PRESTWICK
KA9 1LH
Tel.: 01292 470331



SCALE 1:100			
DATE 21/08/08	JOB NO.	DRG NO.	REV
Drawn by JAMES REID	Passed by	Issued for	