



TYPICAL ALCOHOL DISPLAY ARRANGEMENT

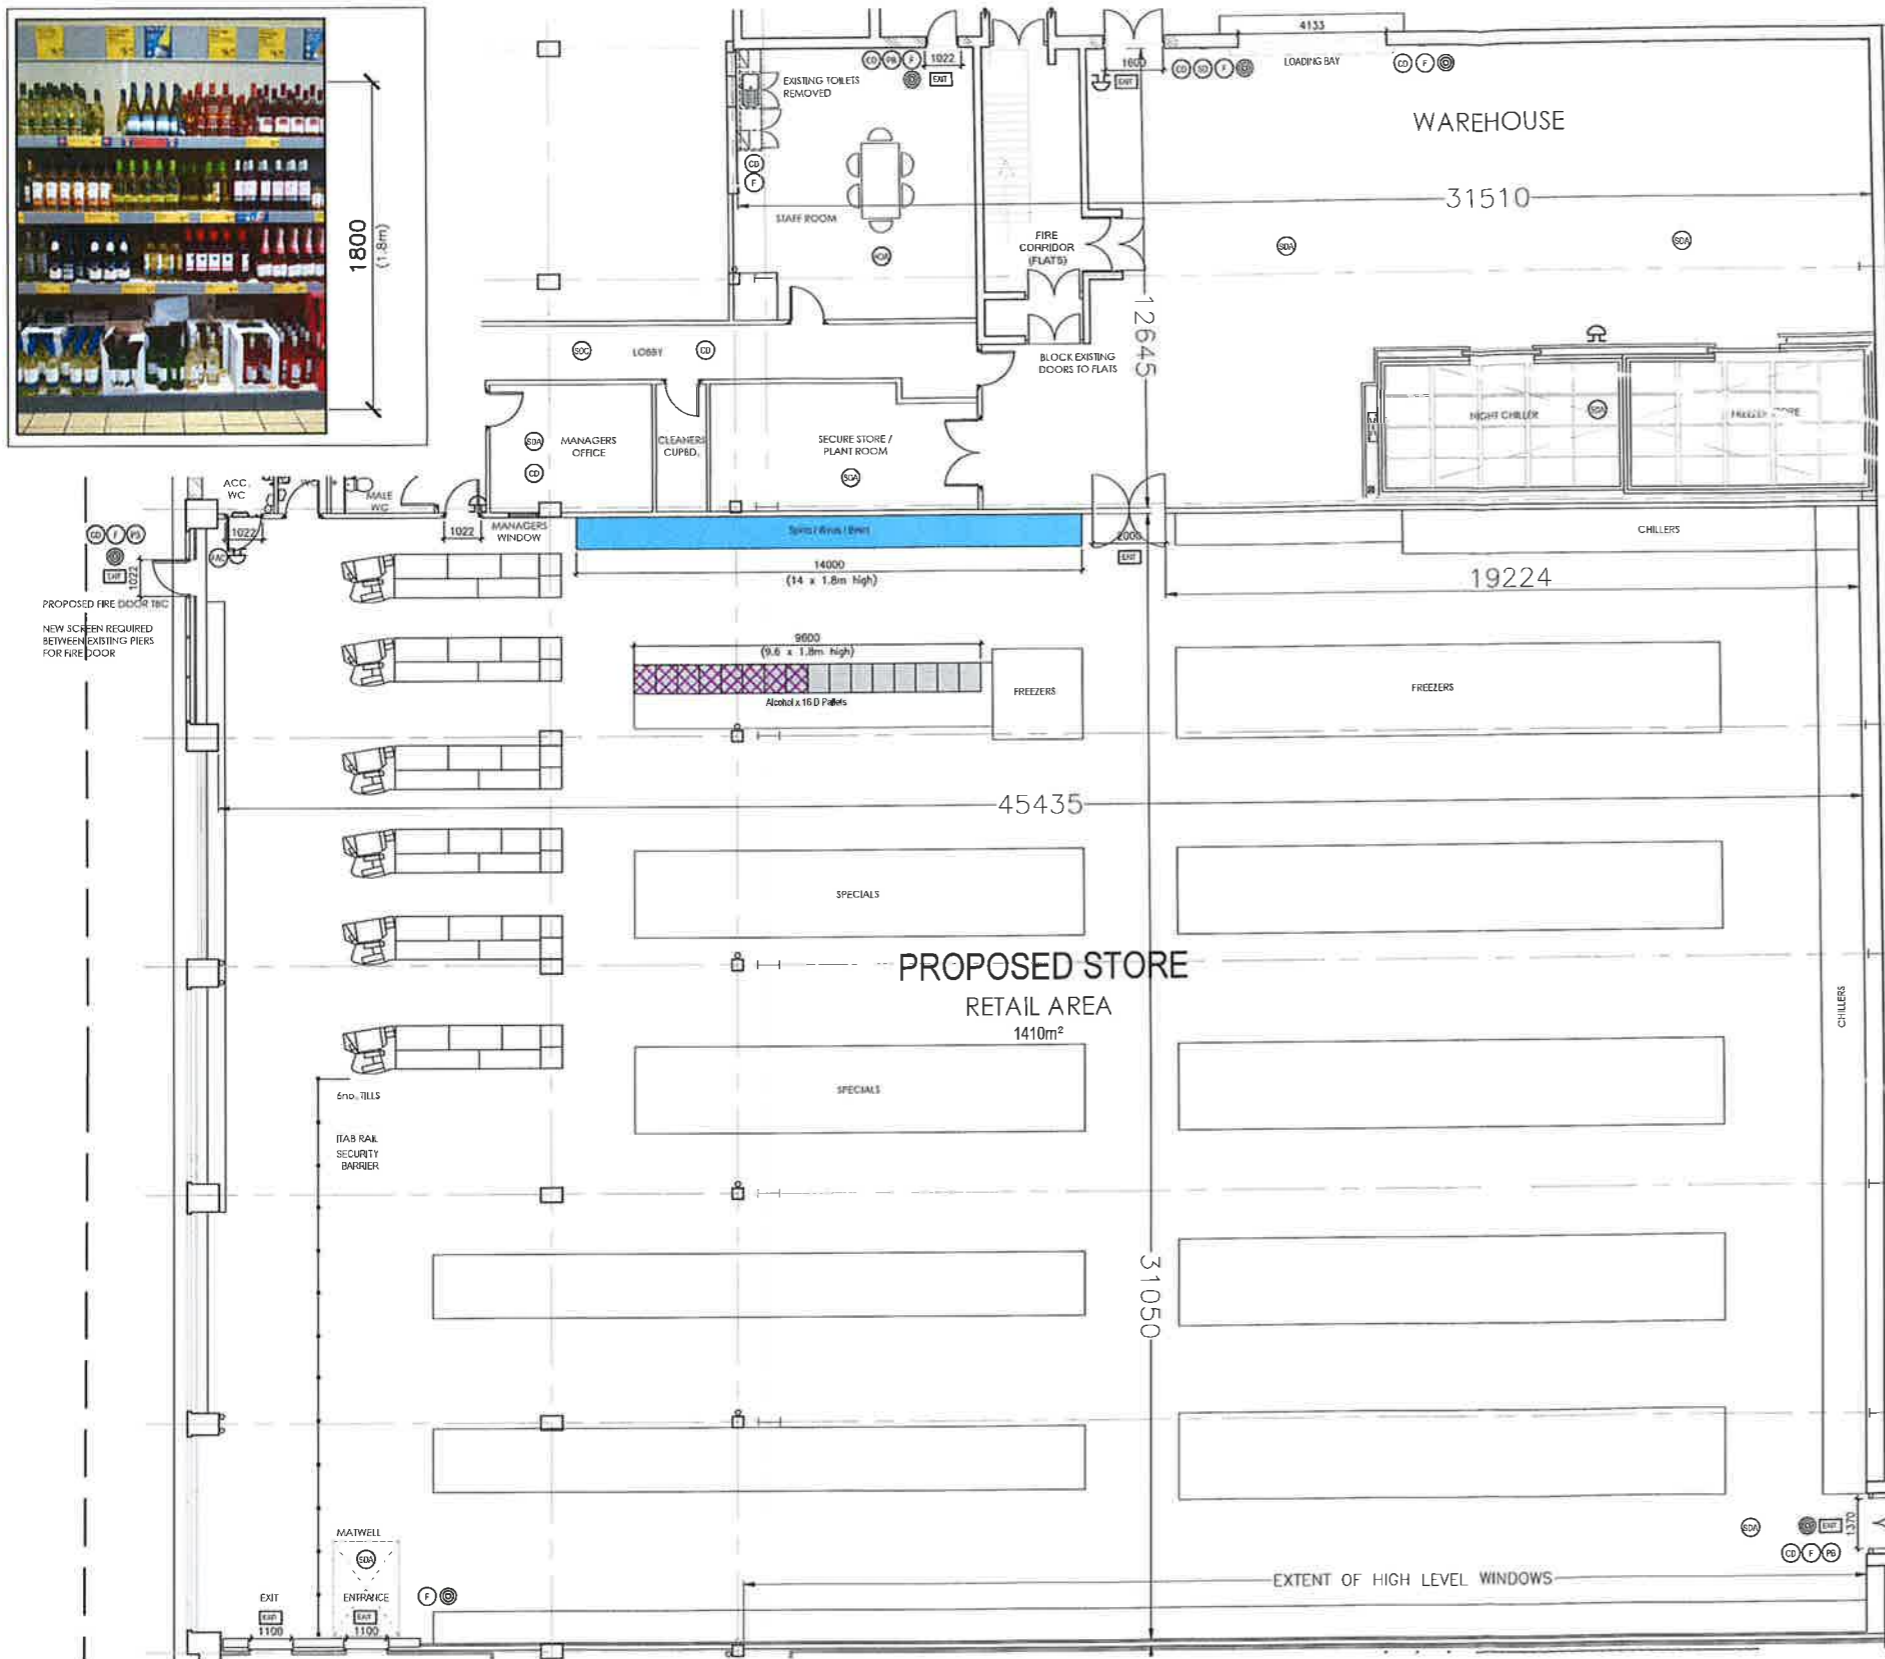

SITE PLAN  
(SCALE 1:1250 @A3)

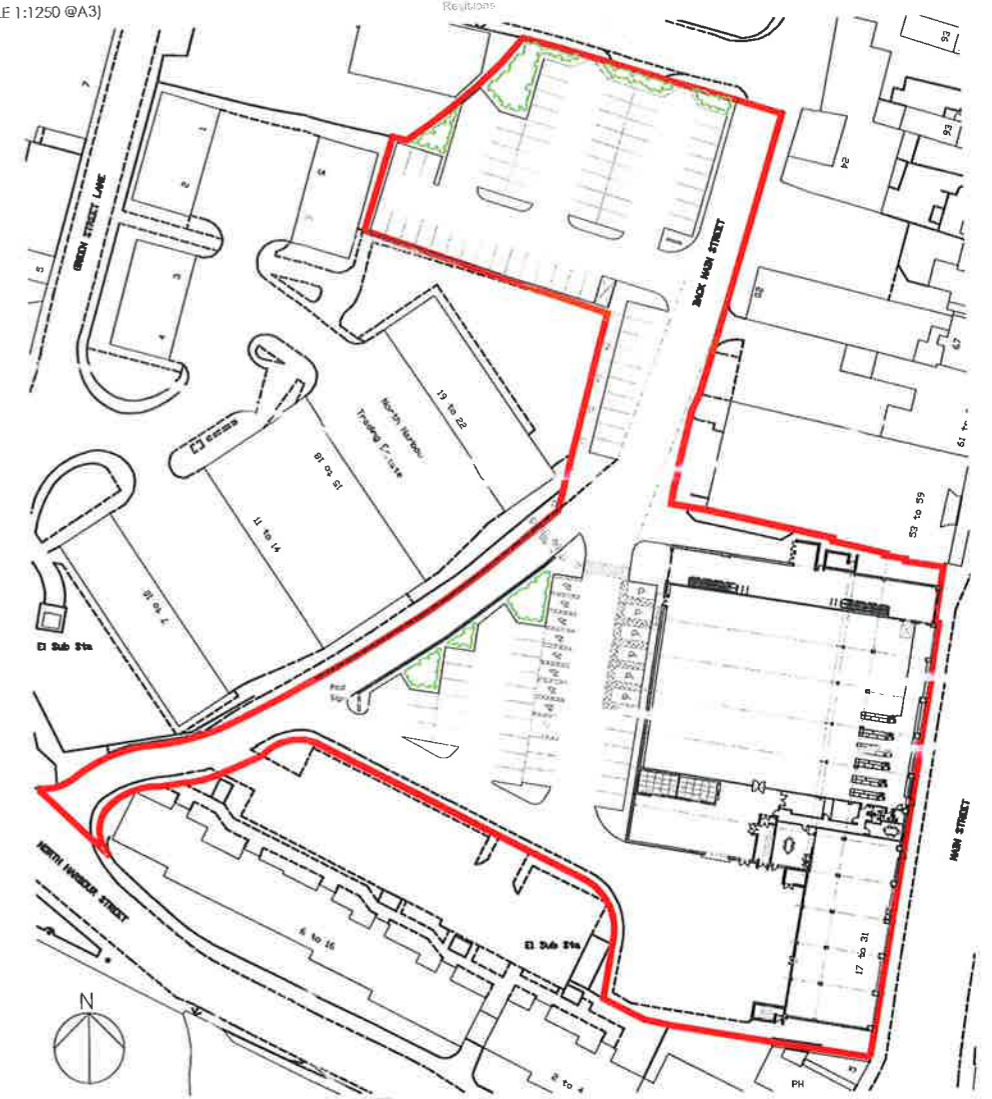

**ALCOHOL MERCHANDISE LEGEND:**

- Shelf (4 Tier Flexible)
- D Pallet
- D Pallet with shelf over

**FLEXIBLE SHELVING**

- 1500mm From floor to top of shelf 4
- 1075mm From floor to top of shelf 3
- 675mm From floor shelf 1 to top of shelf 2

FIRE EQUIPMENT/DETECTION LEGEND:

- FIRE ALARM CALL POINT (BREAK GLASS UNIT)
- FOAM SPRAY AFFF FIRE EXTINGUISHER
- CARBON DIOXIDE FIRE EXTINGUISHER
- SMOKE DETECTOR
- VOID SMOKE DETECTOR - CEILING MOUNTED INDICATOR
- FIRE ALARM SMOKE DETECTOR & SOUNDER
- FIRE ALARM HEAT DETECTOR & SOUNDER
- FIRE ALARM CONTROL PANEL
- FIRE ALARM BELL
- ILLUMINATED FIRE EXIT SIGN

FLOOR PLAN  
(SCALE 1:200 @A3)



NOTES:  
CHILDREN AND YOUNG PERSONS ARE PERMITTED IN ALL PUBLIC AREAS OF THE PREMISES

Client  
**ALDI Stores Ltd.**

Project Address  
**33 Main Street, AYR**

Drawn  
**PG**  
Date  
**09.12.13**

Checked by  
**GD**  
Scale  
**VARIES @A3**



Project  
**ALDI AYR**  
Drawing Title  
**Proposed Alcohol License Plan**

Drawing Number  
**0126 - AL(76)100**

Projekt Architects  
Coquet Street  
Media Exchange 2  
Newcastle upon Tyne  
NE1 2QB

t: 0191 2605551

e: admin@projektarchitects.com  
www.projektarchitects.com

