


note:  
do not scale from drawings. discrepancies in figured dimensions to be notified to the architect.

rev: description: drawn: chkd: date:

A - Client comments TW 10-02-15

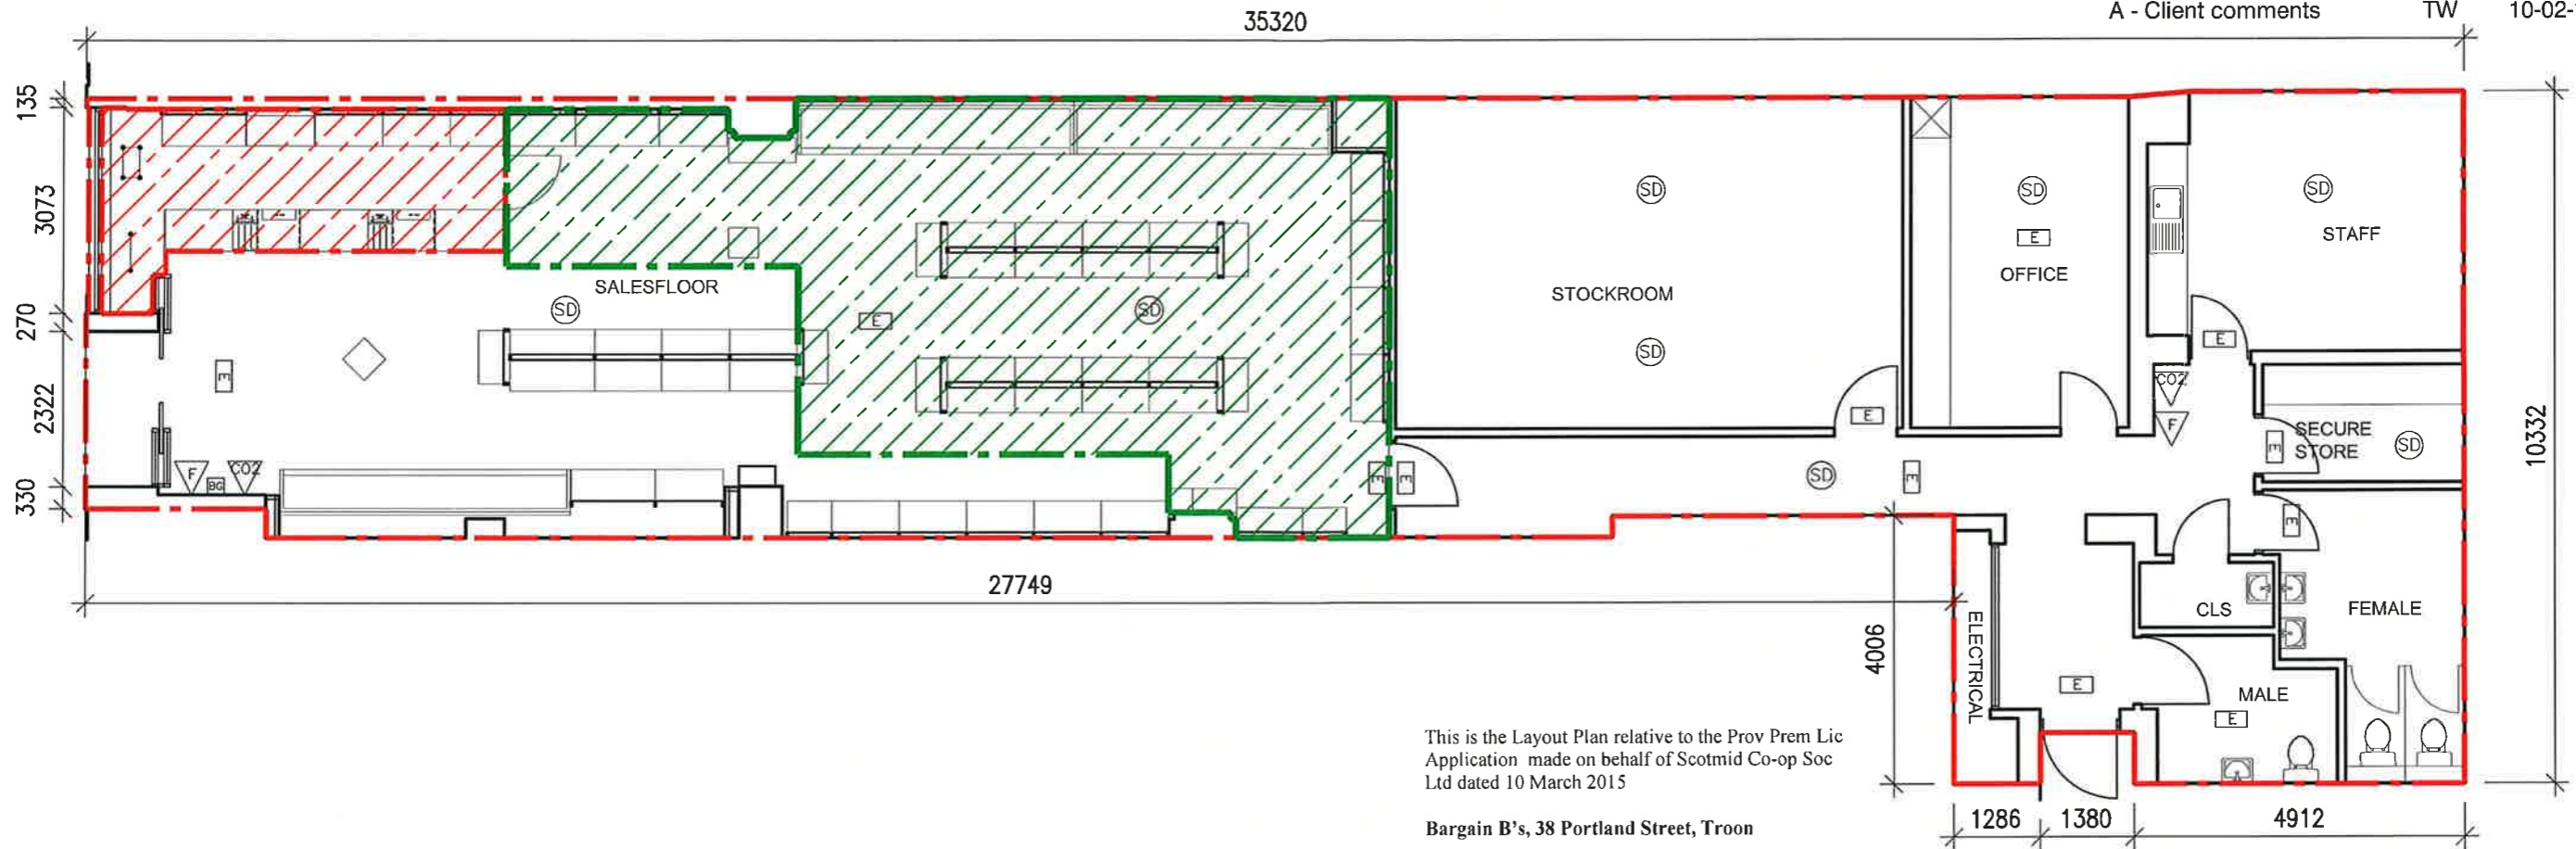

This is the Layout Plan relative to the Prov Prem Lic Application made on behalf of Scotmid Co-op Soc Ltd dated 10 March 2015

Bargain B's, 38 Portland Street, Troon

R & J M Hill Brown & Co Ltd  
(DWG No. 1338 L(10)1A) *CR*



**smithfindlay:architects**

2 Merkland Street T 0141 334 4995 E design@smithfindlay.co.uk  
Glasgow G11 6DB F 0141 334 8186 W www.smithfindlay.com

project:

38 PORTLAND STREET, TROON  
STORE NO:-

title:  
LICENSE APPLICATION LAYOUT PLAN

scale: drawn: checked: date:  
1:100@A3 TW 01/15

job:	drawing number:	rev:
1338	L(10)1	A

Areas	
	Secure alcohol display area
Alcohol Display Frontage -	
Length	5.1m
Height	2.4m
Capacity	12.24m <sup>2</sup>
	Open alcohol sales area
Alcohol Display Frontage -	
Length	40m
Height	2.4m
Capacity	96.0m <sup>2</sup>
Stacked Alcohol Display	
Length	2m
Height	1.5m
Capacity	3.0m <sup>2</sup>
Total Capacity = 111.24m <sup>2</sup>	

LEGEND

- SMOKE DETECTOR
- EMERGENCY LIGHT
- CARBON DIOXIDE EXTINGUISHER
- FOAM EXTINGUISHER
- WATER EXTINGUISHER
- BREAK GLASS UNIT

Emergency lighting system to comply with British Standard 5266: Part 1: 1999. (Maintained- 2hour duration) and BS EN 1838:1999 (or BS 5266-7: 1999)

Firefighting Equipment to comply with British Standard EN3, British Standard 7863: 1996, British Standard 5306-3: 2000 and British Standard 5306-8: 2000

Signs and notices to comply with the Health and Safety (Safety Signs and Signals) Regulations 1996 and / or British Standard 5499: Part 1: 1990.

Any information contained in this drawing which is not required by regulation 5 of SSI 2007/452 is included for illustrative purposes only and does not form part of the layout plan for the purposes of the said regulation or the Licensing (Scotland) Act 2005