




THE TREEHOUSE

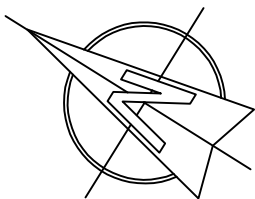

- ☒ BREAK GLASS UNIT
- ☒ ALARM SOUNDER
- Ⓢ SMOKE DETECTOR
- Ⓜ HEAT DETECTOR
- ⚡ CEILING MOUNTED EMERGENCY LIGHTING
- ⚡ WALL MOUNTED EMERGENCY LIGHTING
- ☒ CO2 CO2 FIRE EXTINGUISHER
- ☒ W WATER FIRE EXTINGUISHER
- ☒ P POWDER FIRE EXTINGUISHER
- ☒ FB FIRE BLANKET
- ☒ WC WET CHEMICAL
- ☒ F FOAM
- bc BABY CHANGING UNIT

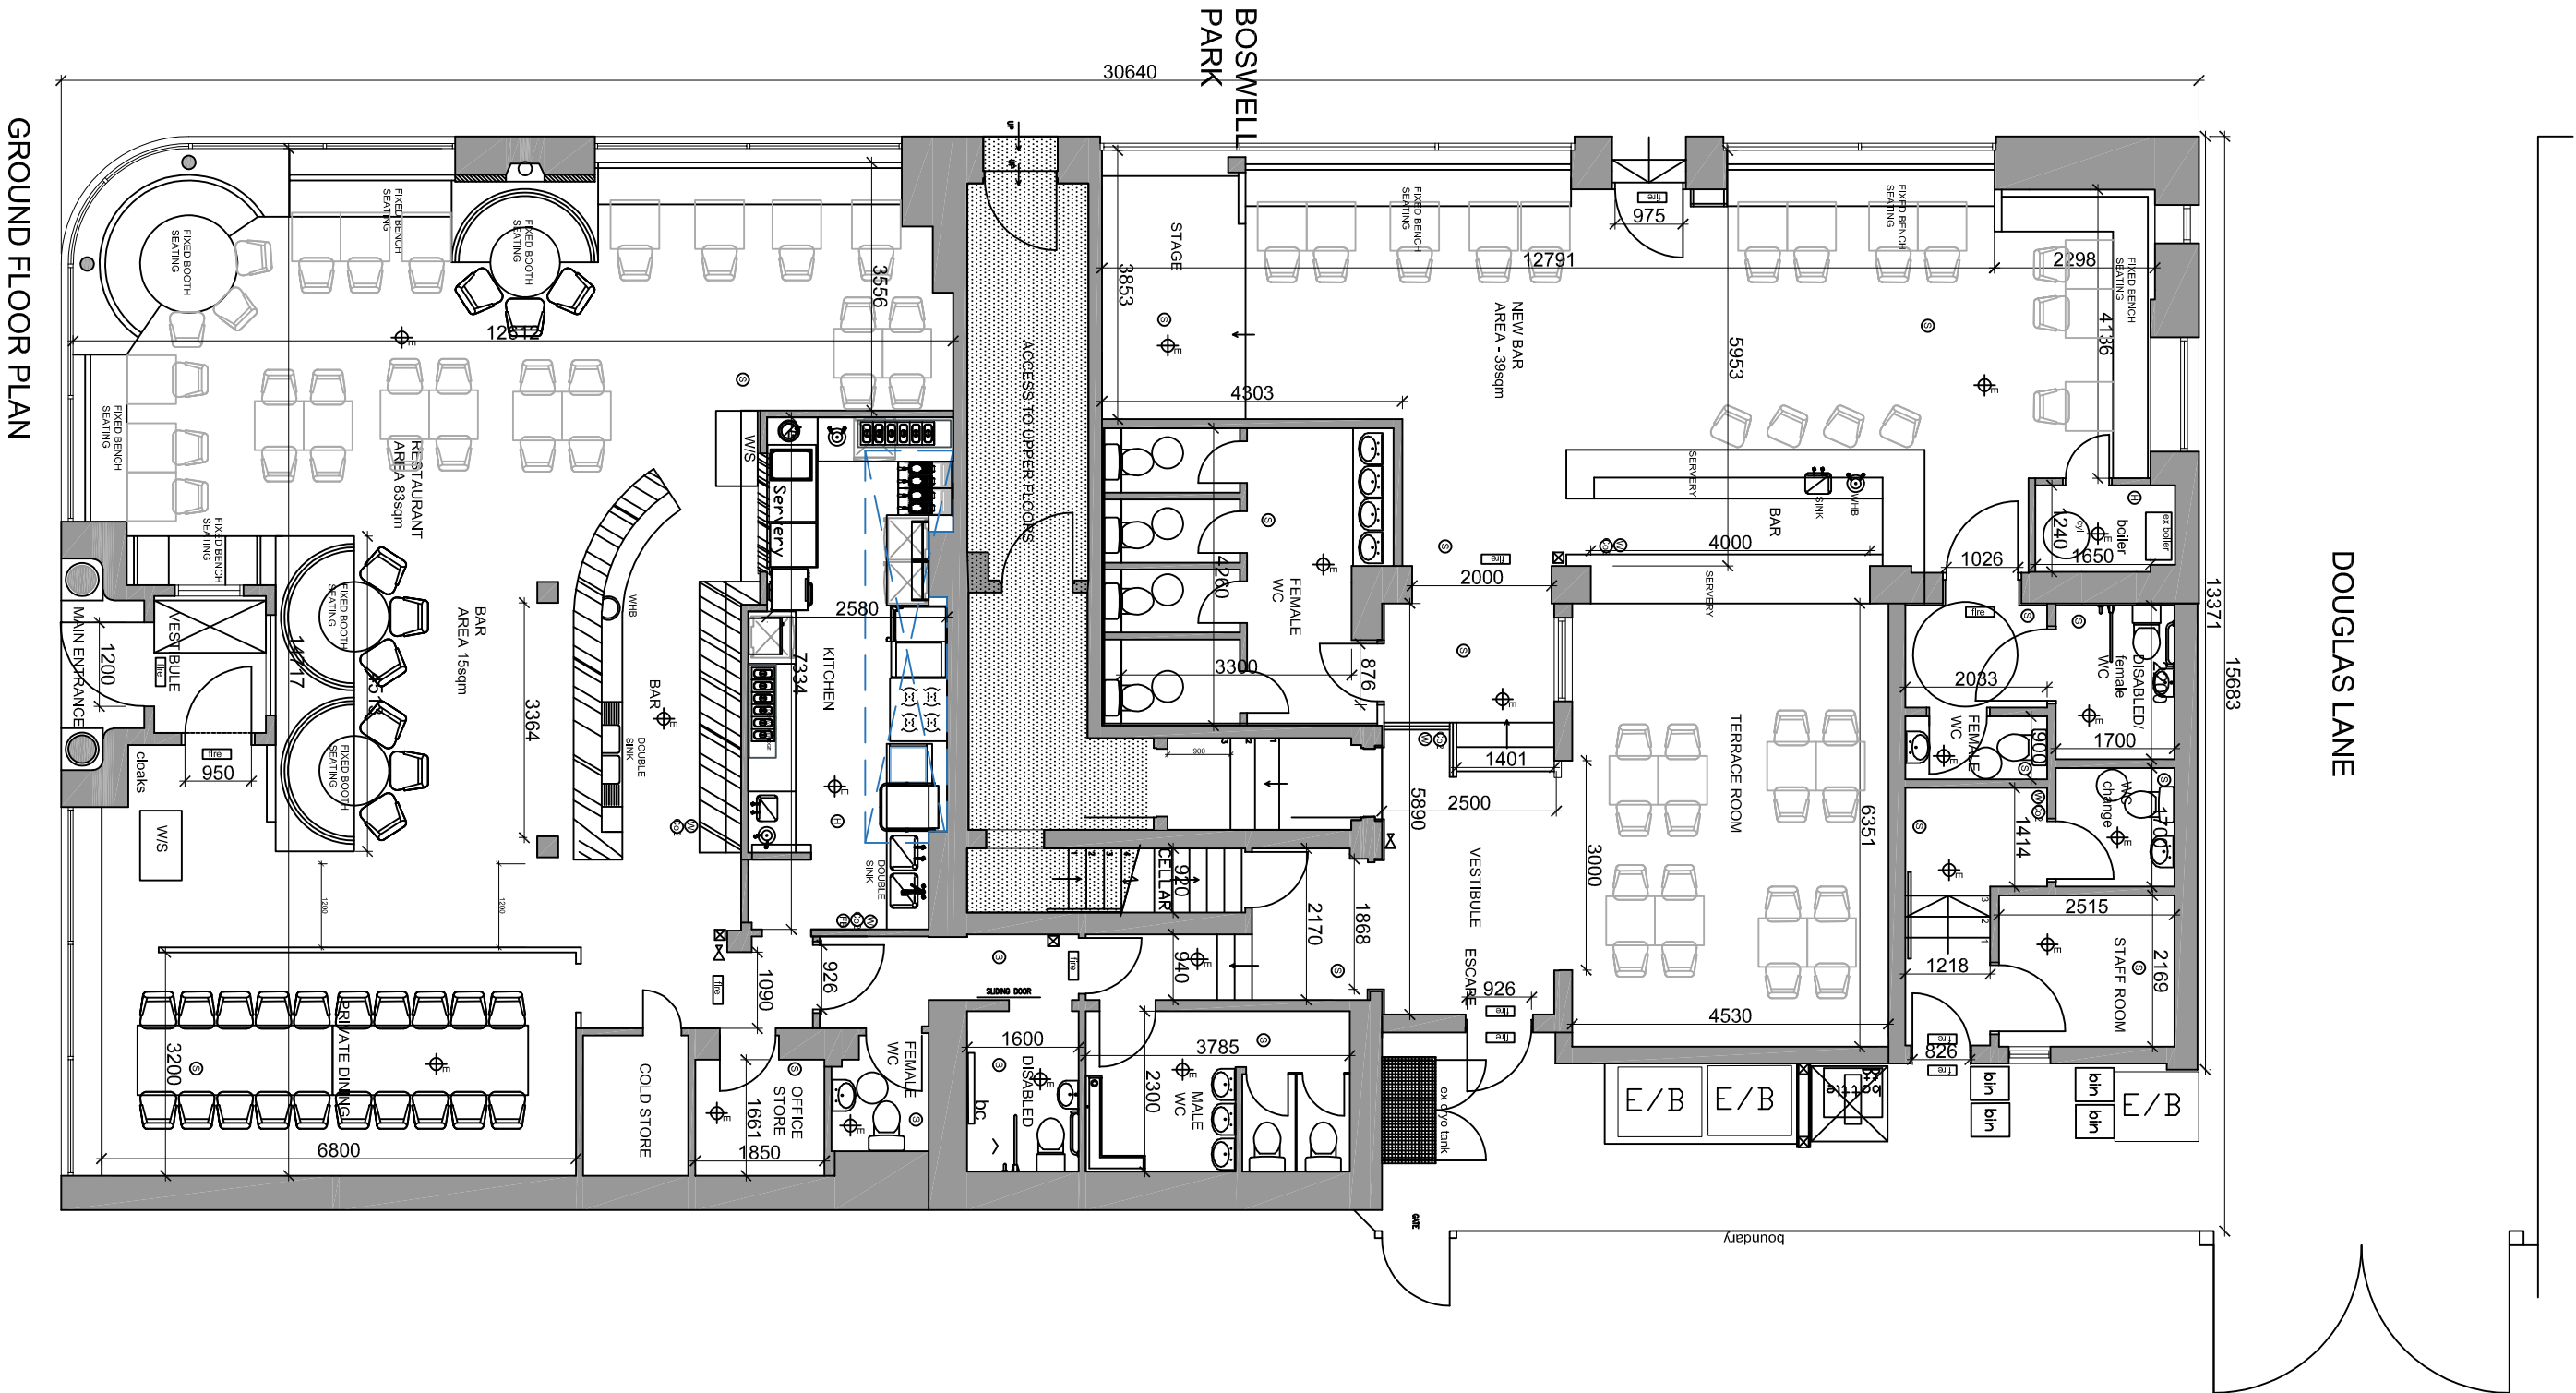

GROUND FLOOR PLAN

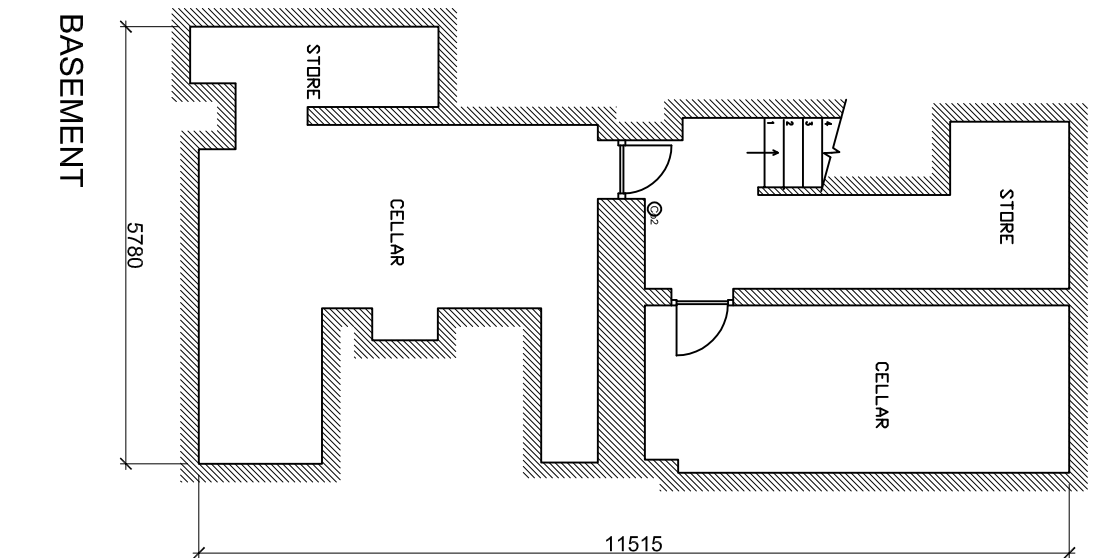


BASEMENT



LOCATION PLAN

Crown Copyright 2006. All rights reserved. Licence number 100020449

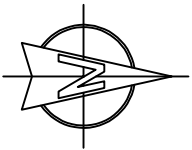

BAR FLOOR AREA = 56.3 SQ.M
TERRACE ROOM FLOOR AREA = 28.8 SQ.M
RESTAURANT FLOOR AREA = 93 SQ.M
TOTAL BAR & RESTAURANT FLOOR AREA = 178.1 SQ.M

BAR AREA = 56.3 SQ.M
@ 2 PERSONS PER 1 SQ.M = 112.6 PERSONS
TERRACE ROOM = 28.8 SQ.M
@ 2 PERSONS PER 1 SQ.M = 57.6 PERSONS
RESTAURANT AREA = 93 SQ.M
@ 1 PERSONS PER SQ.M = 93 PERSONS
TOTAL 263.2 PERSONS

C	BAR ADDED TO LICENSED AREA	110118
B	ROOM NAMES UPDATED	301017
A	LAYOUT AMENDED	OCT 17
JOB	Bar / Restaurant	
DRAWING	The Treehouse	
	Licensing Plan	
SCALE	1:100	DRAWN MDS
DATE	Jun 17	
DRAWING NO	6320/LIC - 01	REV C
CLIENT	Buzzworks Holdings Ltd	

ARPL ARCHITECTS
11 WELLINGTON SQUARE, Ayr
TEL 01292 289777

