


Craig Tara Holiday Park

Proposed Turnberry Gardens Redevelopment - Proposed License Plan



Copyright. This drawing is the property of A&M Architectural Partnership. It is not to be reproduced, stored in a retrieval system, or used in any form, or by any means, without the prior written permission of the Architect. The drawing incorporates information from other professionals. For the information and use of other professionals, the Architect does not accept any liability for any errors or omissions in this drawing, or for any consequences that may arise from its use. The drawing is for information only and does not constitute an offer of any services. All dimensions are in millimeters unless otherwise stated. Report any alterations or omissions to the Architect. Do not scale the drawing. Drawings can be scaled for planning purposes only. All dimensions on site shall comply with any work, or otherwise stated. Report any alterations or omissions to the Architect. This drawing incorporates information from other professionals. For the information and use of other professionals, the Architect does not accept any liability for any errors or omissions in this drawing, or for any consequences that may arise from its use. The drawing is for information only and does not constitute an offer of any services. All dimensions are in millimeters unless otherwise stated. Report any alterations or omissions to the Architect. Do not scale the drawing. Drawings can be scaled for planning purposes only. All dimensions on site shall comply with any work, or otherwise stated. Report any alterations or omissions to the Architect.

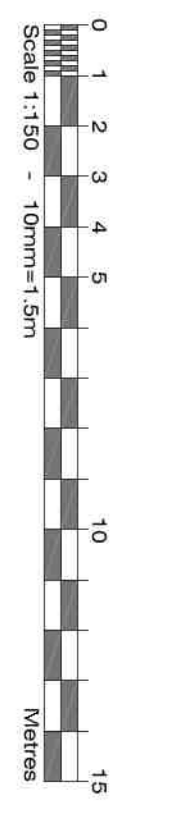

- Fire Alarm Legend**
- ① BREAK GLASS MANUAL CALL POINT
 - ② HEAT DETECTOR (RED WIRE)
 - ③ HEAT DETECTOR (TYPE RATE OF RISE)
 - ④ SMOKE DETECTOR (OPTICAL TYPE)
 - ⑤ SMOKE DETECTOR (PULSED IONISED)
 - ⑥ SMOKE DETECTOR (ULTRASONIC/DOPE)
 - ⑦ SMOKE DETECTOR (BEAM TYPE (REVERSE))
 - ⑧ SMOKE DETECTOR (BEAM TYPE (UNIDIRECTIONAL))
 - ⑨ ELECTRONIC SOUNDER
 - ⑩ COMBINATION KEYFOLD SOUNDER & ELECTRONIC KEYFOLD SOUNDER
 - ⑪ MAGNETIC DOOR HOLDER
 - ⑫ FREQUENCY SOUNDER
 - ⑬ FIRE ALARM INTERFACER
 - ⑭ FIRE ALARM PANEL
 - ⑮ FIRE ALARM UNIT
 - ⑯ VIBRATOR FIRE ALARM UNIT
 - ⑰ SMOKE DETECTOR WITH INTEGRAL SOUNDER
 - ⑱ HEAT DETECTOR WITH INTEGRAL SOUNDER
 - ⑲ COMBINED SMOKE DETECTOR, SOUNDER & COMBINED HEAT DETECTOR, SOUNDER & SOUNDER

LEGEND

- █ BAR & CELLAR
- █ TOILET ACCOMMODATION
- █ AREA SPECIFIC FOR THE USE OF CHILDREN & YOUNG PERSONS
- █ AREA LICENSEABLE BY ALL USERS INCLUDING CHILDREN & YOUNG PERSONS

NOTES TO BE IN ACCORDANCE WITH THE LOCAL SCHEDULES, MASSING AND ELEVATION OF THE BUILDING (SCOTLAND) REGULATIONS 2004.

CONSTRUCTION, CLASSIFICATION AND SITUATION OF BUILDINGS. BUILDING CLASSES AS CLASS A.

MAINTAIN EVACUATION TIME: 3 MIN

ESCAPE ROUTES SURFACE SPREAD OF FLAME TO BE CLASS 0, CLASS 1 ESCAPE ROUTES TO BE CLASS 0, CLASS 1 OR CLASS 2. ESCAPE ROUTES TO BE CLASS 0, CLASS 1 OR CLASS 2. ESCAPE ROUTES TO BE CLASS 0, CLASS 1 OR CLASS 2. ESCAPE ROUTES TO BE CLASS 0, CLASS 1 OR CLASS 2. ESCAPE ROUTES TO BE CLASS 0, CLASS 1 OR CLASS 2.

MEANS OF ESCAPE

ESCAPE ROUTES SURFACE SPREAD OF FLAME TO BE CLASS 0, CLASS 1 OR CLASS 2. ESCAPE ROUTES TO BE CLASS 0, CLASS 1 OR CLASS 2. ESCAPE ROUTES TO BE CLASS 0, CLASS 1 OR CLASS 2. ESCAPE ROUTES TO BE CLASS 0, CLASS 1 OR CLASS 2.

ALL DOORS, WINDOWS AND OPENINGS TO BE FITTED WITH SELF-CLOSING DEVICES AND FIRE DOOR - KEEP SHUT SIGNAGE.

DISABLED PERSONS

ACCESS AND MEANS OF ESCAPE FOR DISABLED PERSONS TO BE IN ACCORDANCE WITH BS 5829 PART 1. PROVIDE MEANS OF ESCAPE FOR DISABLED PEOPLE TO BE APPLIED WHERE PRACTICAL.

EMERGENCY LIGHTING

EMERGENCY LIGHTING INSTALLED TO COMPLY WITH BRITISH STANDARDS BS 5266 (BS EN 1829: 1999) ALL EXIT POINTS INDICATED BY RED LIT PANELS WITH EMERGENCY LIGHTING IN ACCORDANCE WITH BS 5266 PART 1. PROVIDE MEANS OF ESCAPE FOR DISABLED PEOPLE TO BE APPLIED WHERE PRACTICAL.

GENERAL

PROVIDE FIRE FIGHTING EQUIPMENT SUITABLE FOR THE RISK OF THE ACTIVITIES TO BE UNDERTAKEN. PROVIDE MEANS OF ESCAPE FOR DISABLED PEOPLE TO BE APPLIED WHERE PRACTICAL.

WALL & DOOR FIRE RATING

- █ 60MIN. FIRE RATED WALL CONSTRUCTION
- █ 30MIN. FIRE RATED DOORSET - 700SS
- █ 60MIN. FIRE RATED DOORSET - 700SS
- █ NON-FIRE RATED DOORSET
- █ VERTICAL FIRE STOPPING (GLASS) PROVIDING 60 MIN. FIRE RATING
- █ NEW FINAL ESCAPE FIRE EXIT
- █ EXISTING FINAL ESCAPE FIRE EXIT

Venue	Occupancy	Number
External Airbag	5	67
External Zipline	5	140
Bar/Cellar	5	50
Mini Golf	5	100
Sky Tykes	5	13
Climbing Walls	5	17
High Ropes	5	15
TOTAL		310

A&M Architectural Partnership LLP

40 Cambridge Road, Hove, East Sussex, TN34 1DT
T: 01424 800222 | W: aandmarchitectural.co.uk | E: cormac@andm.co.uk

BOURNE LEISURE LTD.

Client: CRAIG TARA HOLIDAY PARK
Danure Road, Ayr, KA7 4JB

Project: Proposed Turnberry Gardens Redevelopment

Drawing Title: Proposed License Plan

Date: 12/10/2018
Scale: 1:150 @ A1
Drawing: H

Checked By:
Drawn:
Project Manager:
Licensing:
Drawing Number: 4131-720
Revision: A

