



Ground Floor Plan

LEGEND	
E	Emergency Lighting
	Smoke Alarm
	Fire Extinguisher

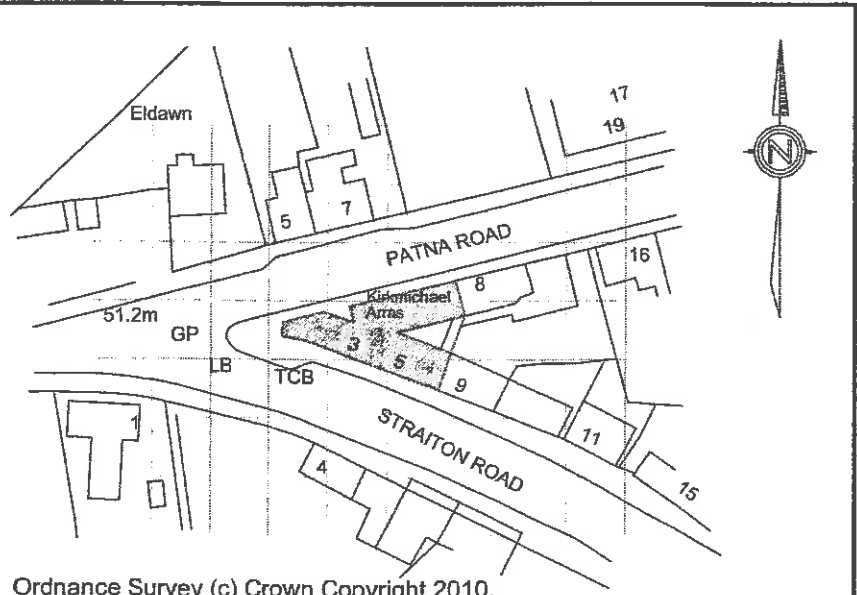

Ordnance Survey (c) Crown Copyright 2010.
All rights reserved. Licence number 100020449
Location Plan - Scale 1:1250

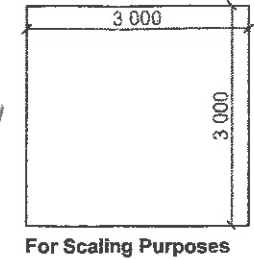

Do not scale - if in doubt ask!

Arctec Designs			
23 Dallas Place, Troon Ayrshire, KA10 6JE Tel:- 01292-319914 Mob:- 07900557838 arctecdesigns@gmail.com			
Client	The Kirkmichael Arms		
Project	The Kirkmichael Arms - 3 Straiton Road, Kirkmichael, KA19 7PH		
Type	Licensing Plan		
Drawing	Ground Floor Plan		
Date	March 2012	Scale	1:100
Drawn By	SMCCR		- A3
Job Ref.	Drawing No.		
10/352	Licensing (d)		