

1st Dec – 2nd Jan ONLY

ALL YEAR ROUND

Alcohol Display Area
Length 5.30m
Height 1.8m
9.54sqm

Alcohol Display Area
Length 31.74m
Height 1.8m
57.13sqm

MAJOR VARIATION
FEBRUARY 2021


CHILDREN AND YOUNG PERSONS ARE
ENTITLED TO ACCESS ALL PUBLIC
AREAS OF THE PREMISES



FIRE SYMBOLS

Scale 1:100

- Portable Water Extinguisher
 - Portable Foam Extinguisher
 - Portable CO₂ Extinguisher
 - Portable Dry Powder Extinguisher
 - Fire Blanket
 - Smoke Detector
 - Heat Detector
 - Warning Device Bell
 - Warning Device Sounder
 - Emergency Light
 - Emergency Exit Illuminated Sign
 - Call Point
 - Warning Device Visual
 - Fire Exit Directional Signage
 - Smoke Detector in ceiling void
 - Fire Control Panel
 - Sprinkler (water)
- All Fire Exits Have A Push Bar & Signage

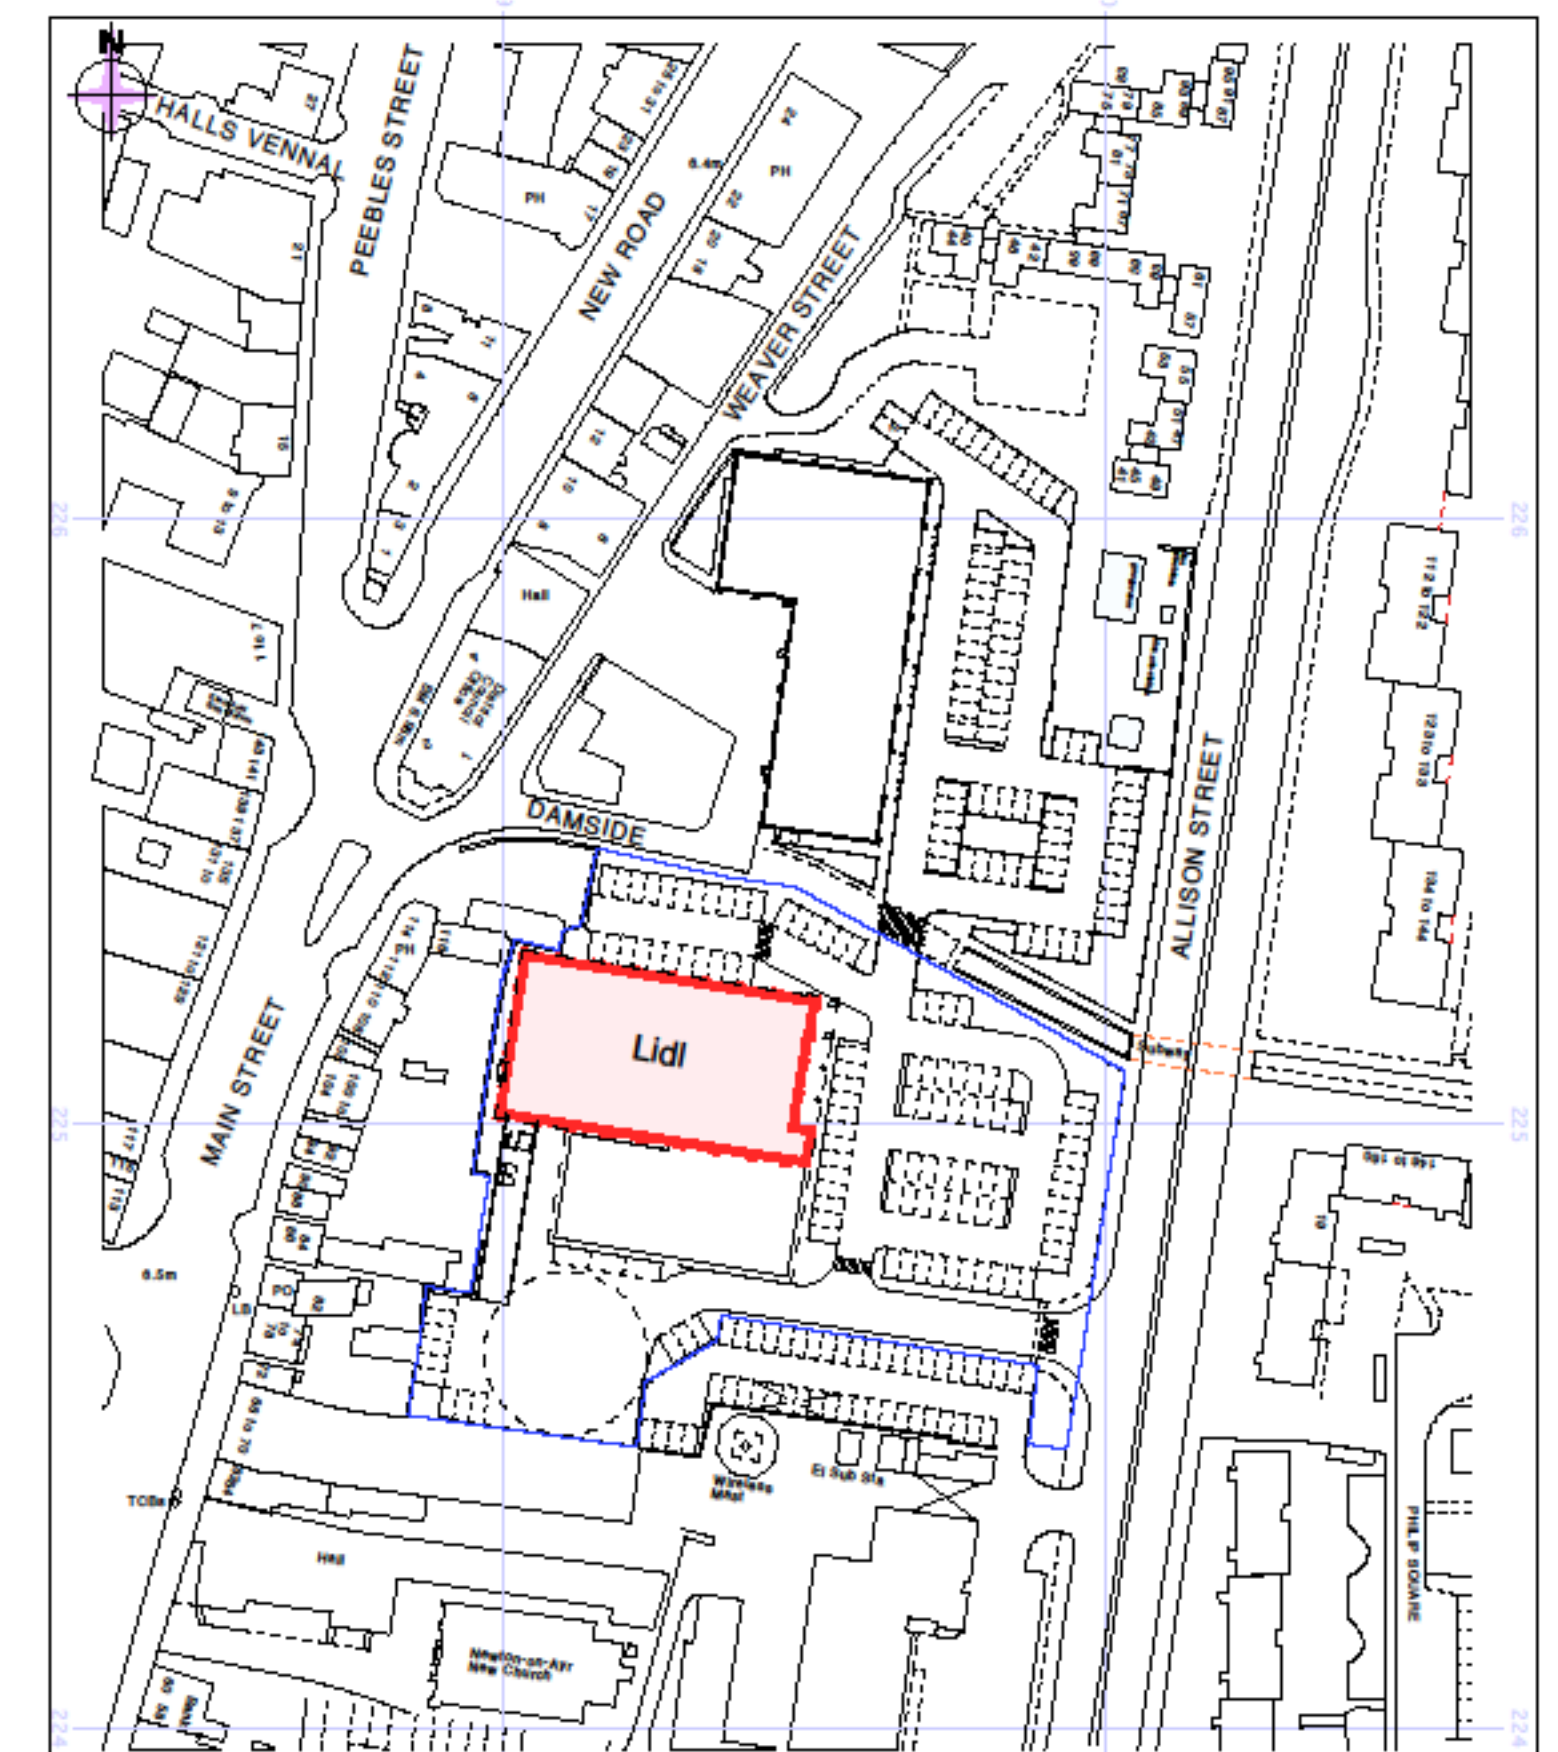

Project Liquor Licence, Allison Street, Ayr		Title Site Plan	
Client Lidl UK GmbH		Project No. G2143-19	Drawing No. LL01
Drawn PJM	Date 29-04-08		
Checked	Scale 1:1250 @ A4		