



C H A R L O T T E S T R E E T L A N E

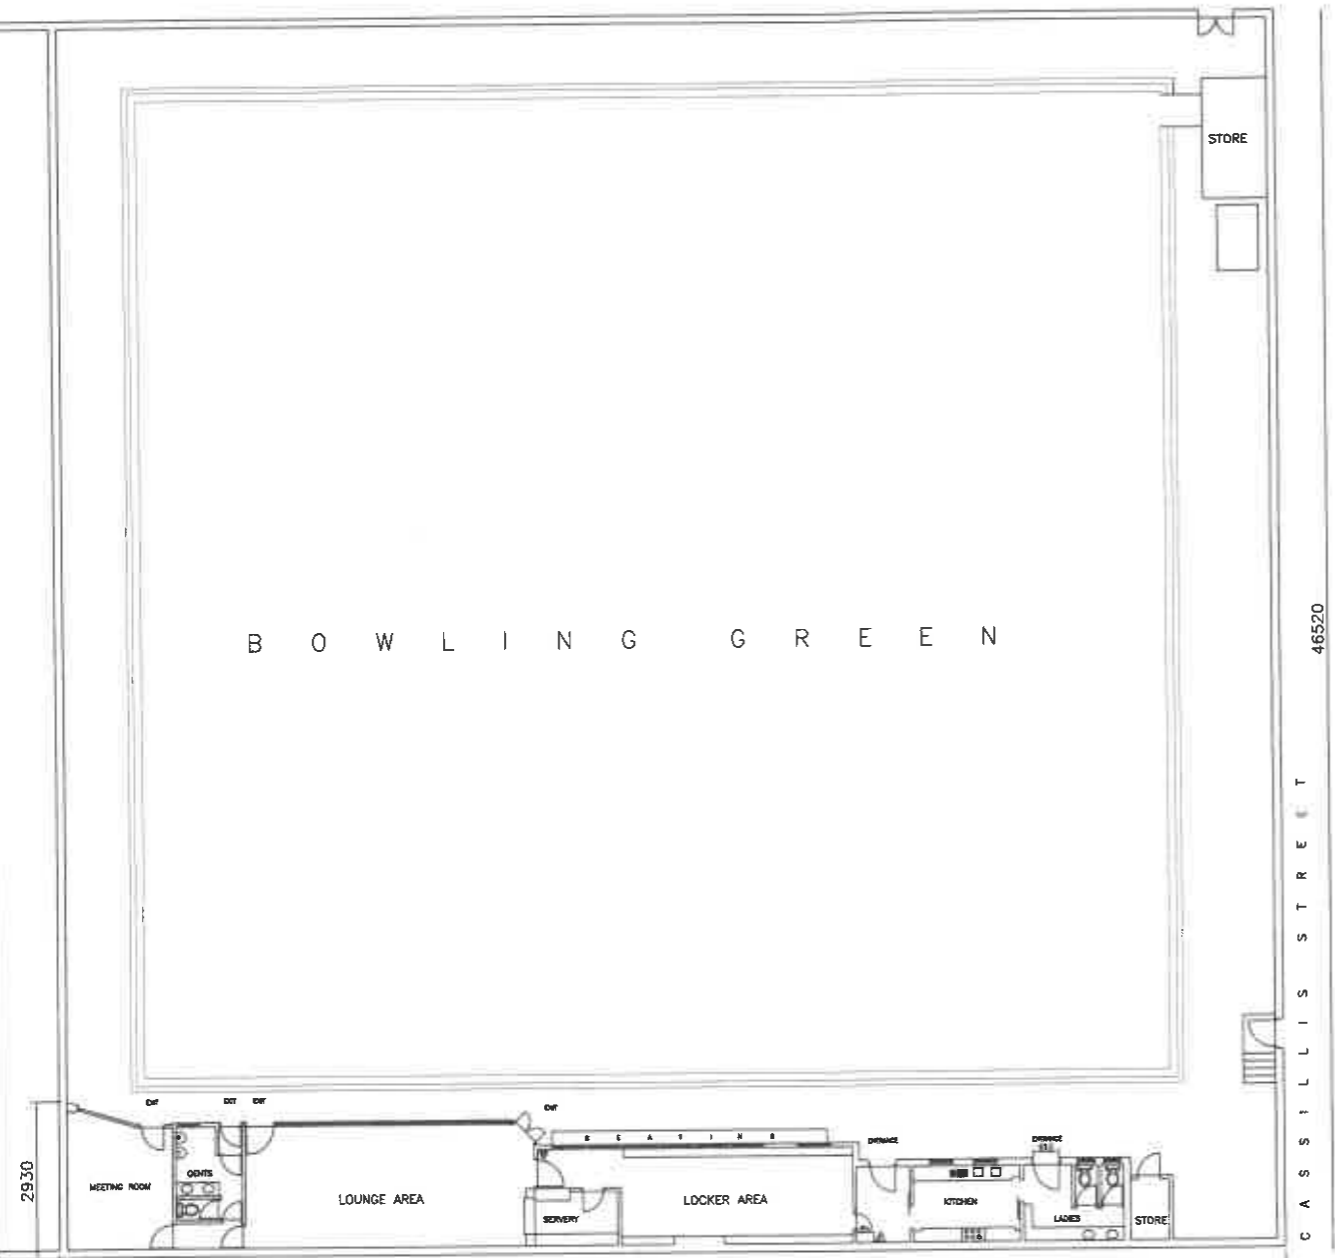

BLOCK PLAN 1/200

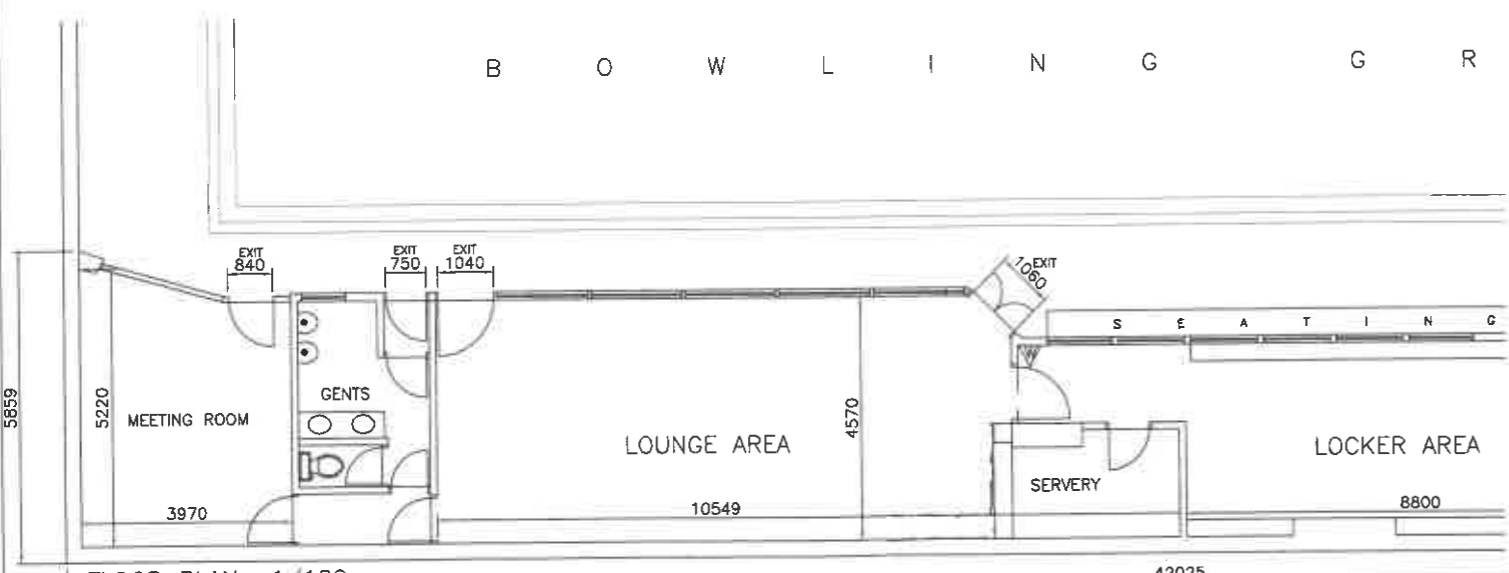

FLOOR PLAN 1/100

LEGEND

- GENERAL FIRE ACTION NOTICE [N1]
- STAFF FIRE ACTION [N2]
- KEEP LOCKED SHUT NOTICE [N3]
- EMERGENCY LIGHTING [EL]
- SMOKE DETECTOR [SD]
- HEAT DETECTOR [HD]
- DRY POWDER EXTINGUISHER [VP]
- FOAM EXTINGUISHER [VF]
- WATER EXTINGUISHER [VW]
- FIRE BLANKET [FB]
- FIRE ALARM CALL POINT [CP]
- FIRE ALARM SOUNDER [AS]
- ILLUMINATE EXIT SIGN [IES]
- CARBON DIOXIDE EXTINGUISHER [VCD]

PROJECT
AYR BOWLING CLUB
CASSILLIS STREET, AYR

TITLE
EXISTING FLOOR PLAN


J. REID & SON
ARCHITECTURAL SERVICES

197 MAIN ST
PRESTWICK
KA9 1LH
Tel.: 01292 470331

SCALE
1:100
1:200

DATE	JOB NO.	DRG NO.	REV
07/09/22			

Drawn by	Passed by	Issued for
JAMES REID		

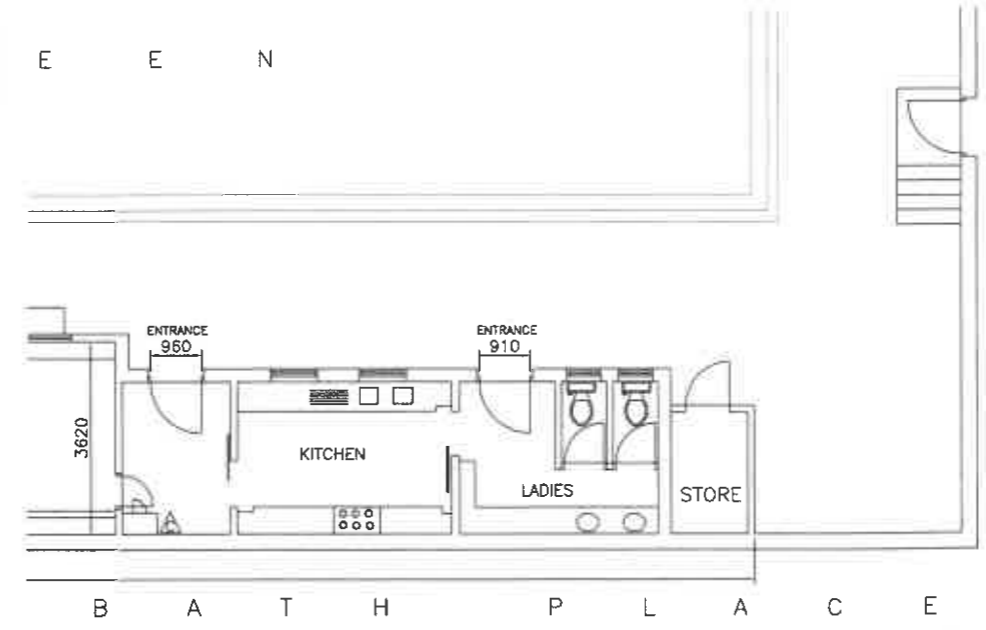

B A T H P L A C E

C A S S I L L I S S T R E E T