


P O R T L A N D S T R E E T

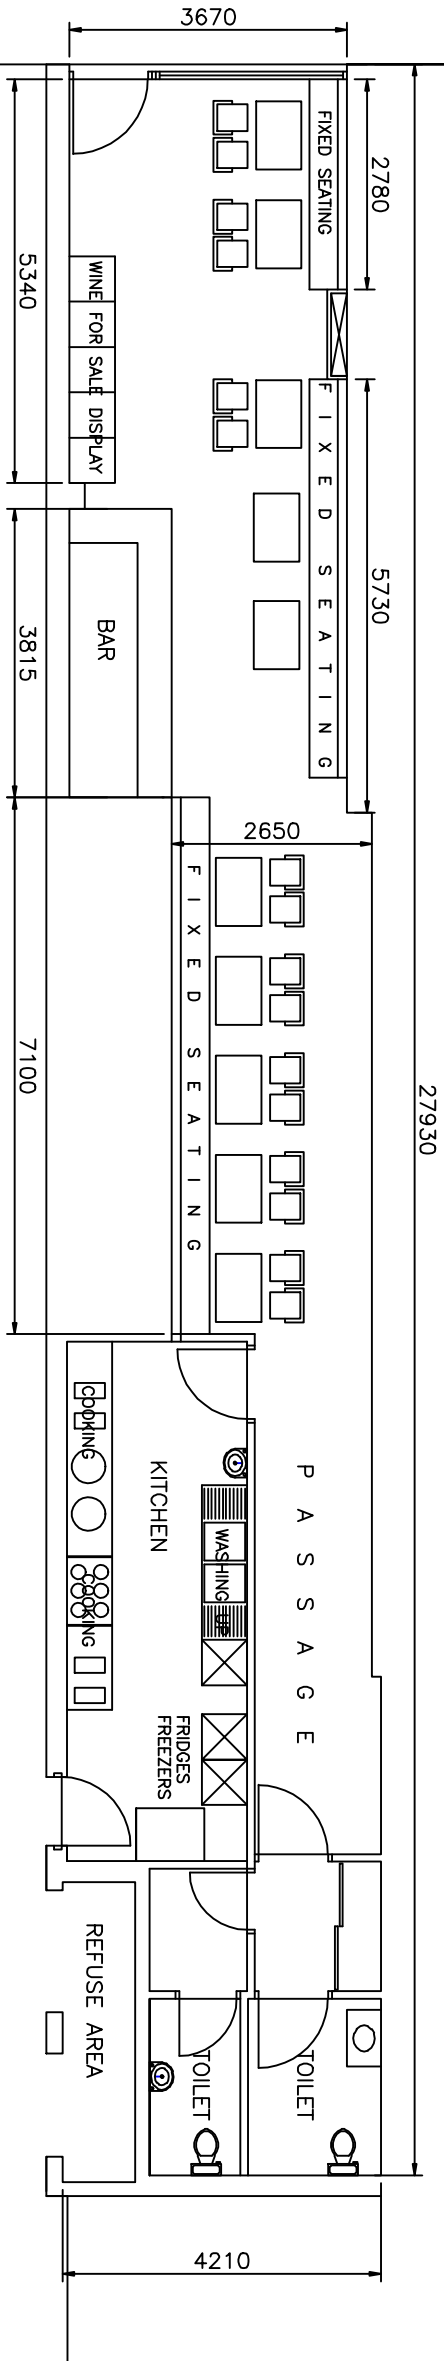

PROPOSED GROUND FLOOR PLAN 1/100

PROJECT
20 PORTLAND STREET
TROON
KA10 6EA

TITLE
PREMISES PLAN

SCALE
1:100

DATE	JOB NO.	DRG NO.	F
13/6/23			
Drawn by	Passed by	Issued for	

LEGEND

- GENERAL FIRE ACTION NOTICE
- STAFF FIRE ACTION
- KEEP LOCKED SHUT NOTICE
- EMERGENCY LIGHTING
- SMOKE DETECTOR
- HEAT DETECTOR
- DRY POWDER EXTINGUISHER
- FOAM EXTINGUISHER
- WATER EXTINGUISHER
- CARBON DIOXIDE EXTINGUISHER
- FIRE BLANKET
- FIRE ALARM CALL POINT
- FIRE ALARM SOUNDER
- ILLUMINATED EXIT SIGN