


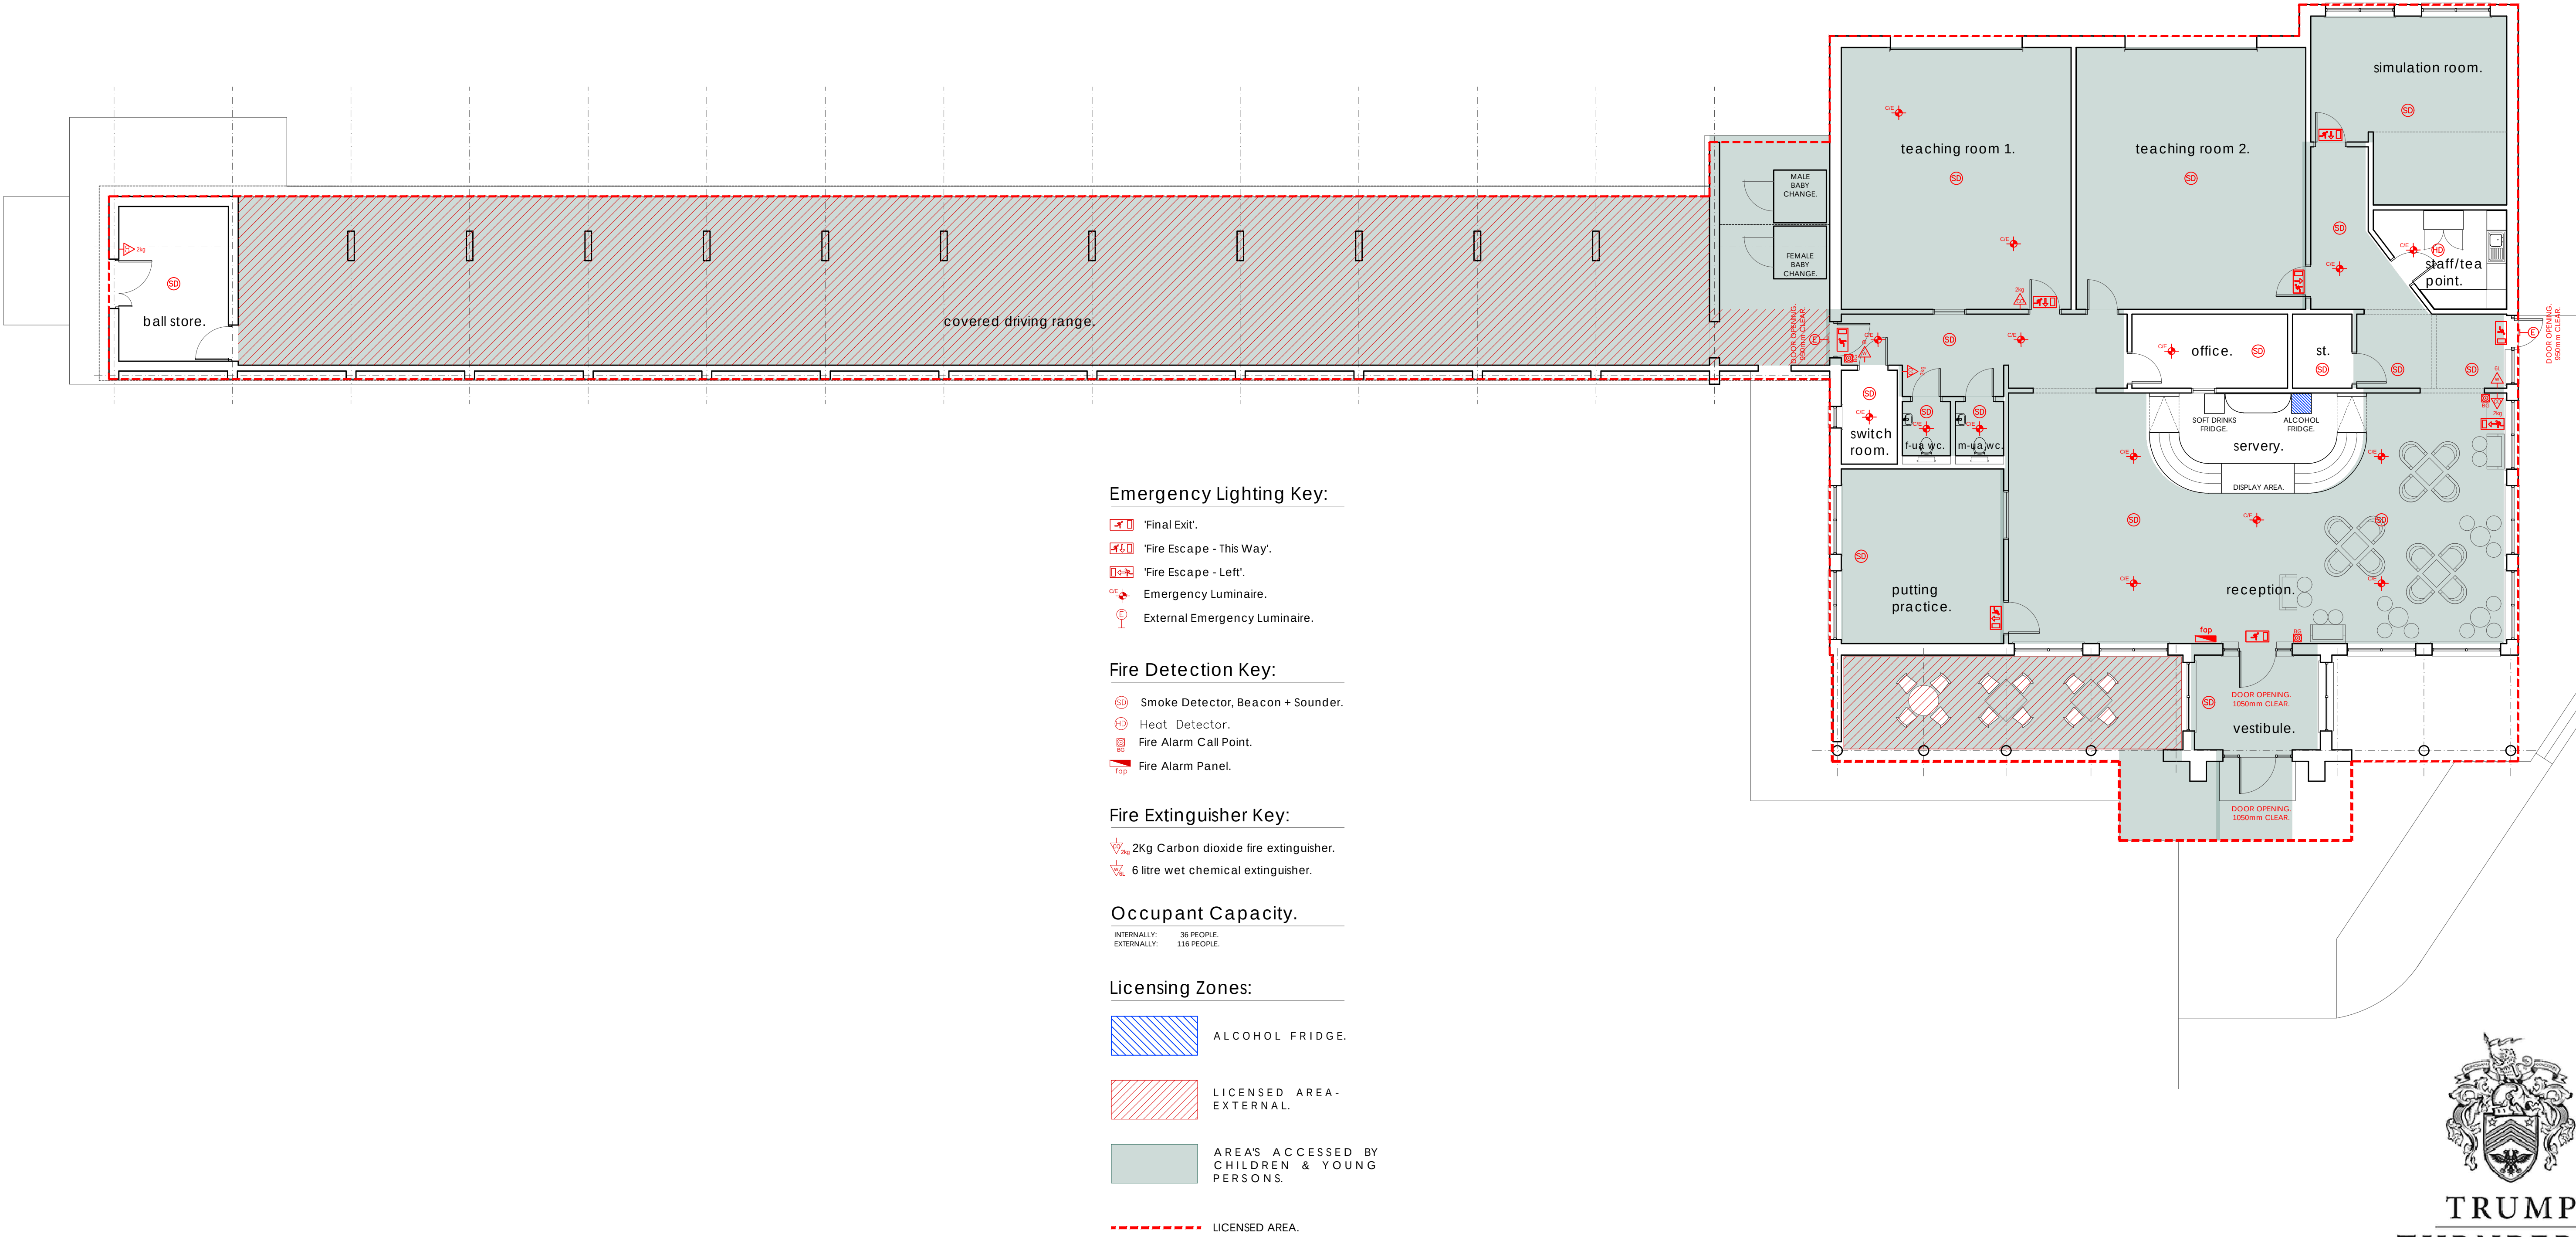

Emergency Lighting Key:

- Final Exit.
- Fire Escape - This Way.
- Fire Escape - Left.
- Emergency Luminaire.
- External Emergency Luminaire.

Fire Detection Key:

- Smoke Detector, Beacon + Sounder.
- Heat Detector.
- Fire Alarm Call Point.
- Fire Alarm Panel.

Fire Extinguisher Key:

- 2Kg Carbon dioxide fire extinguisher.
- 6 litre wet chemical extinguisher.

 
Occupant Capacity.

INTERNALLY: 96 PEOPLE.
EXTERNALLY: 116 PEOPLE.

Licensing Zones:

- ALCOHOL FRIDGE.
- LICENSED AREA - EXTERNAL.
- AREAS ACCESSED BY CHILDREN & YOUNG PERSONS.
- LICENSED AREA.

Golf Academy : Licensng Floor Plan.



This drawing is copyright and the property of m+a+p. Do not scale from this drawing - if in doubt please ask. Use figured dimensions only. Any discrepancies are to be reported.



TRUMP
TURNBERRY

status: LICENSING

client: TRUMP TURNBERRY

project: GOLF ACADEMY LICENSING
TRUMP TURNBERRY
MALDEN ROAD,
TURNBERRY KA26 9LT

drawing: LICENSING FLOOR PLAN

scale: 1:100@A1 10 dunollie gardens
southcraigs
kilmarnock
ka3 6lp

date: AUG 25

drawn by: JPM t: 01563 257754
m: 07805 656752

drawing no:

2381(2-)002b m+a+p